

Fame of the drawings

ID	Layout name
1.1	Installation layout
1.2	Doors specification
2.1	Measurement layout
2.2	Furniture layout
3.1	Plan of binding sanitary equipment
4.1	Floor coverings layout
5.2	Ceiling layout
6.1	Lights layout
6.4	Groups of lights layout
6.7	Sockets layout
6.10	Switches and Sockets specification
7.1	Wall decoration layout
7.2	Elevation layout 1
7.3	Elevation layout 2
7.4	Elevation layout 3
7.5	Elevation layout 4

Note:

1. It is allowed to make changes to the Design project during the implementation process, subject to agreement with the architect.
2.The visualizations in this album are a conditional indicative image of the finished object and should be considered together with the drawings and equipment.
3.Non-standard structures, complex elements and structural units are developed by the relevant contractor on the basis of the technical specifications issued by the architect.

Project content


Scale
1:50Sheet
1

Architect:


SNAAR

Installation layout

Ground floor

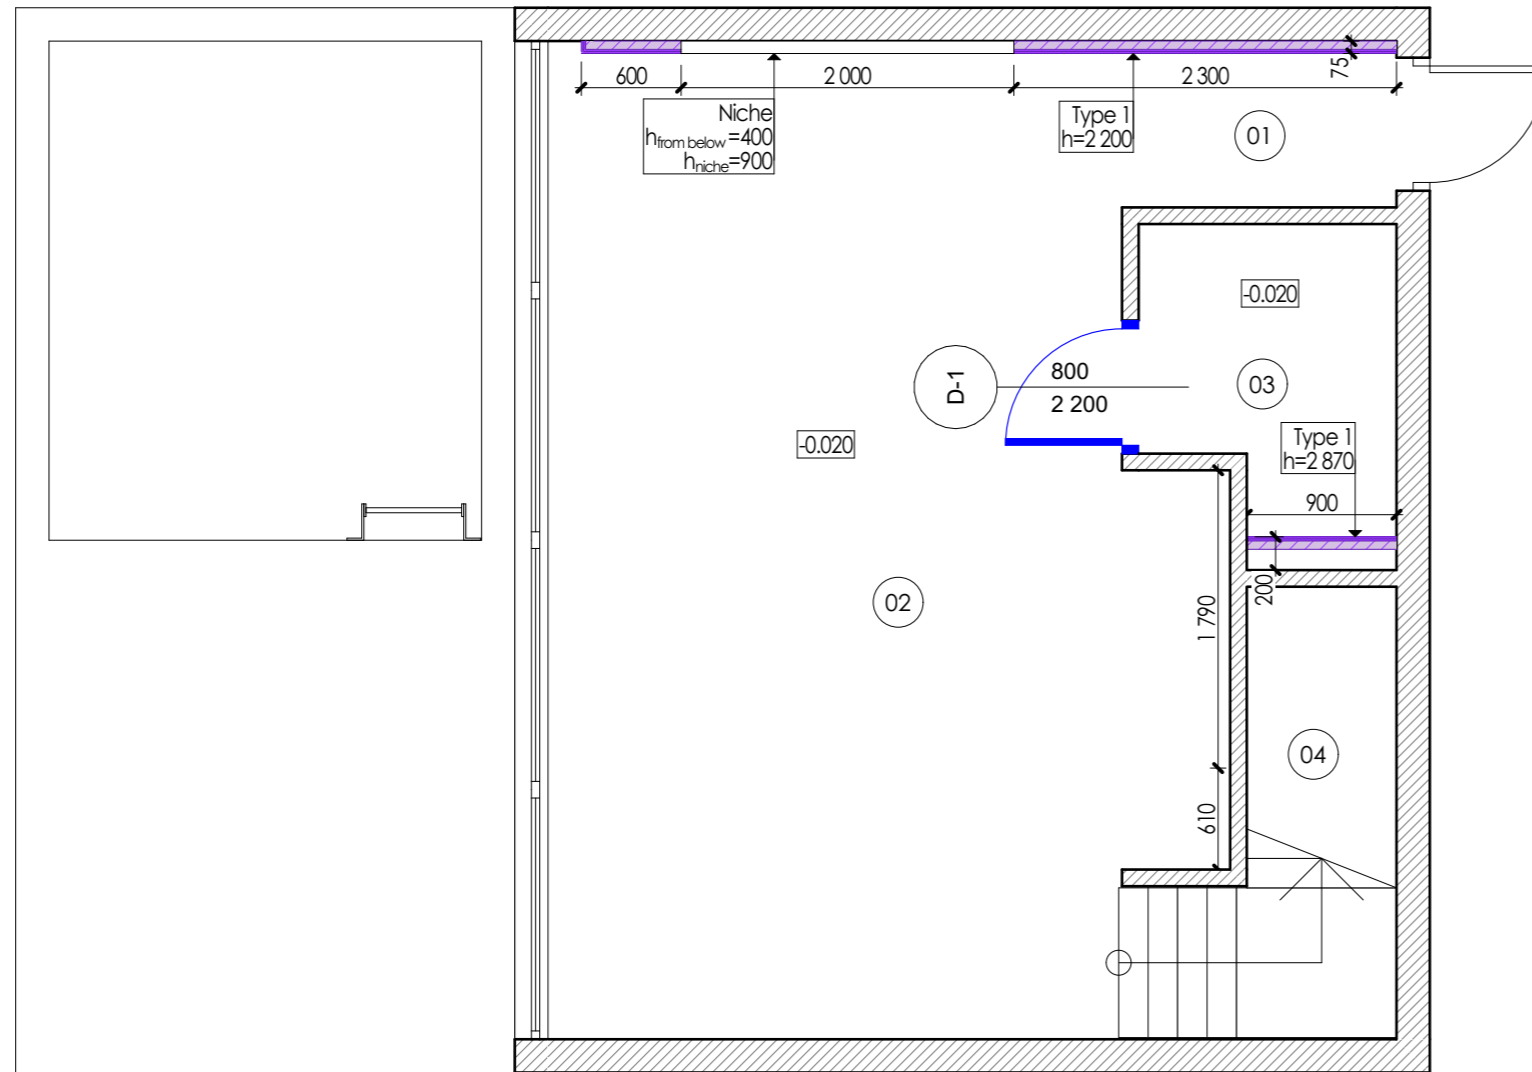

First floor

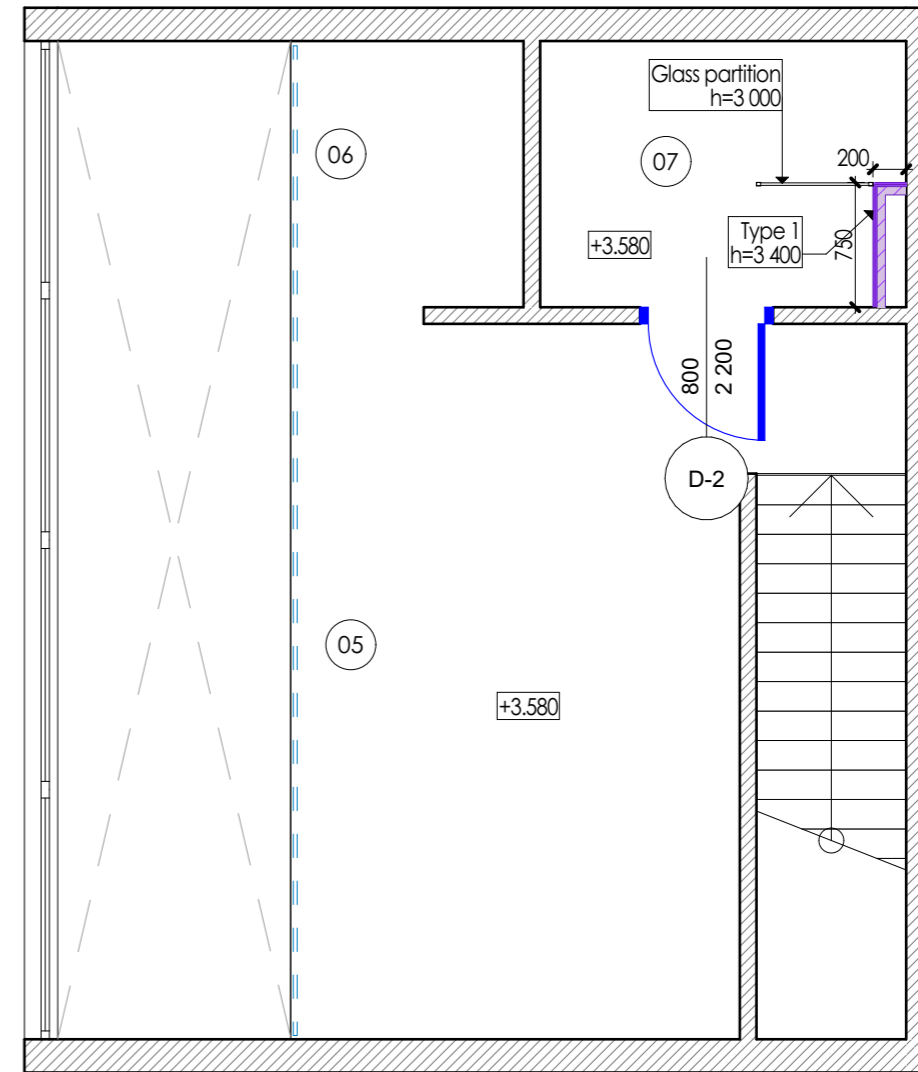

Note:

1. All dimensions are design. Before ordering, manufacturing, installation, it is imperative to perform actual measurements.
2. The color and texture of the materials are agreed only on real samples.
3. In case of changes in dimensions or position in space, coordinate with the project architect.

Premises specification		
No	Name	Area
01	Hall	1,64
02	Living/kitchen/dining	22,19
03	Toilet room	2,59
04	Stairs	3,78

Premises specification		
No	Name	Area
05	Bedroom	12,51
06	Wardrobe	2,32
07	Bathroom	3,52
		48,55 m²

Installation notice						
ID	2D	Type of construction	Width	Length	Height	m3
Ground floor						
Type 1		Aluminum profile 75mm - Drywall 12,5mm, 2 sheet, one side	75	4 900	2 200	0,67
Type 1		Aluminum profile 75mm - Drywall 12,5mm, 2 sheet, one side	75	900	2 870	0,19
First floor						
Type 1		Aluminum profile 75mm - Drywall 12,5mm, 2 sheet, one side	75	876	3 400	0,23
				6 676 mm		1,09 m³

Installation layout

 
 
 

Scale
1:50

Sheet
1.1

Architect:

SNAAR

Doors specification

Doors specification			
1. ID	D-1	D-2	
2. Amount	1	1	2
3. Side of opening			
4. Opposite side			
5. Dimensions Width x height	800x2 200	800x2 200	
6. Type of door	Swing door	Swing door	
7. Door orientation	R	R	
9. Covering inside	MDF panel (wood)	Painting RAL 9001	
8. Covering outside	Ceramic granite Tile 600x600 (beige)	Ceramic granite Tile 600x600 (beige)	
10. Installation method	Door of hidden installation method	Door of hidden installation method	
11. Lock	WC type	WC type	

Note:

1. All dimensions are design. Before ordering, manufacturing, installation, it is imperative to perform actual measurements.
2. The color and texture of the materials are agreed only on real samples.
3. In case of changes in dimensions or position in space, coordinate with the project architect.

Doors specification

Scale
1:50


Sheet
1.2

Architect:


SNAAR

Measurement layout

Ground floor

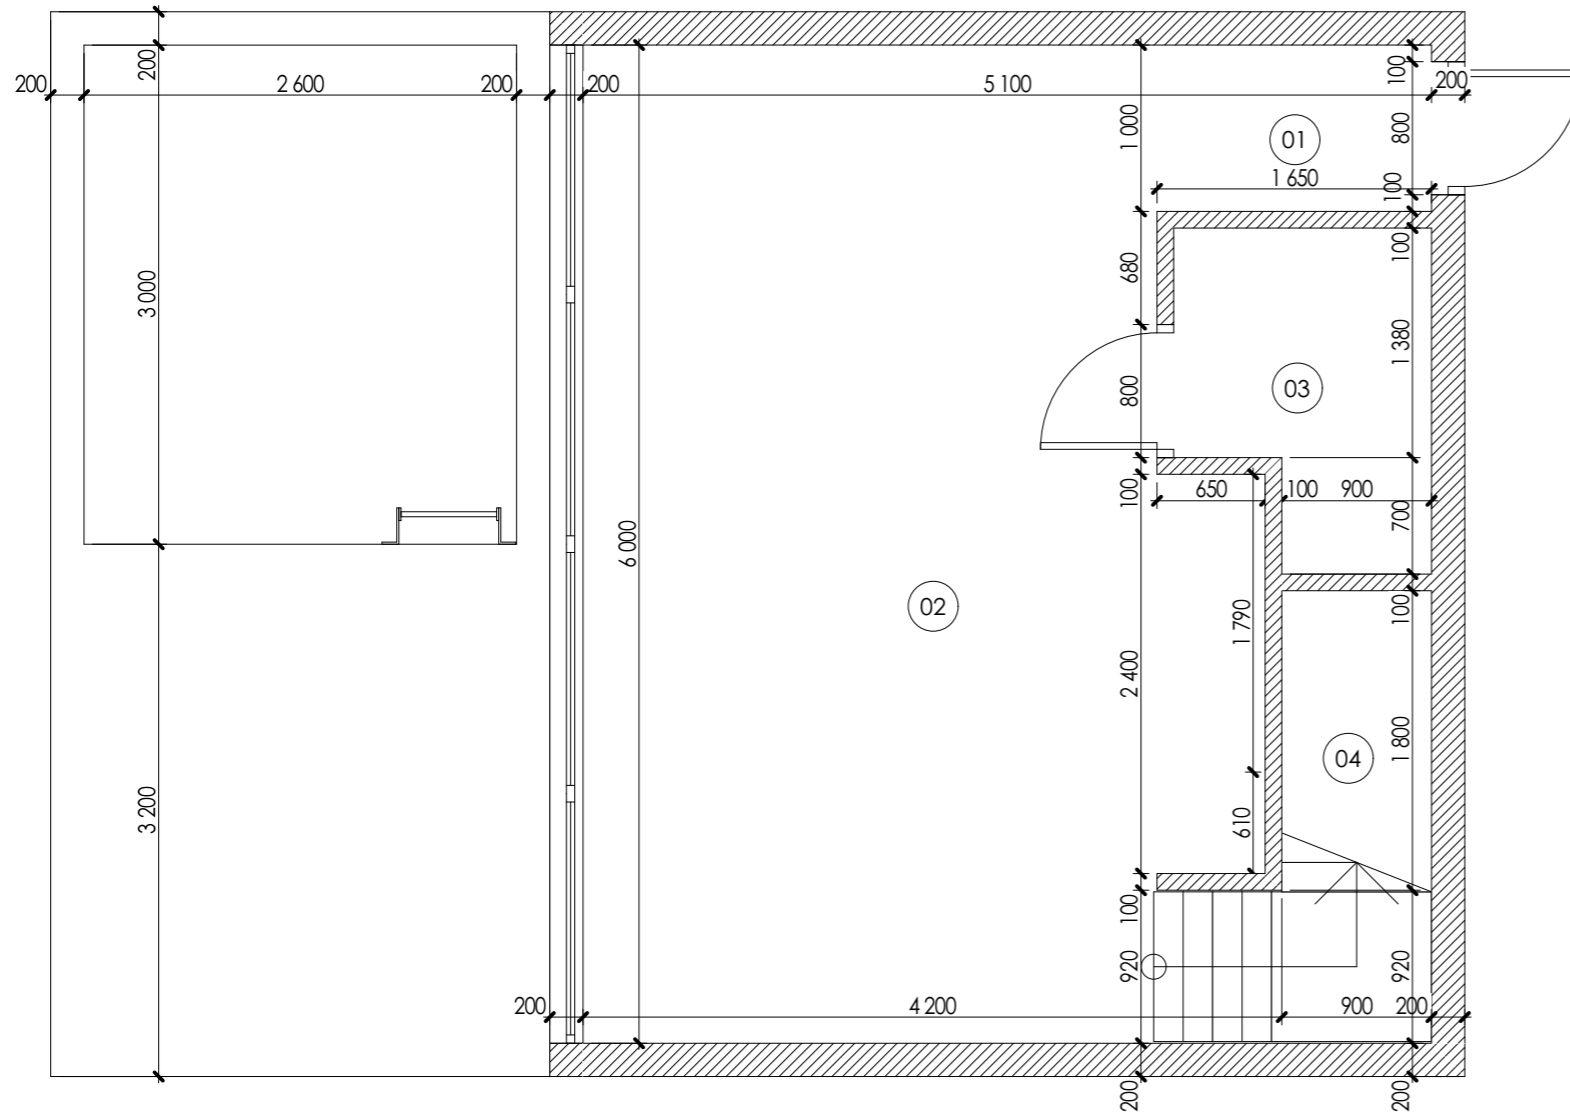

First floor

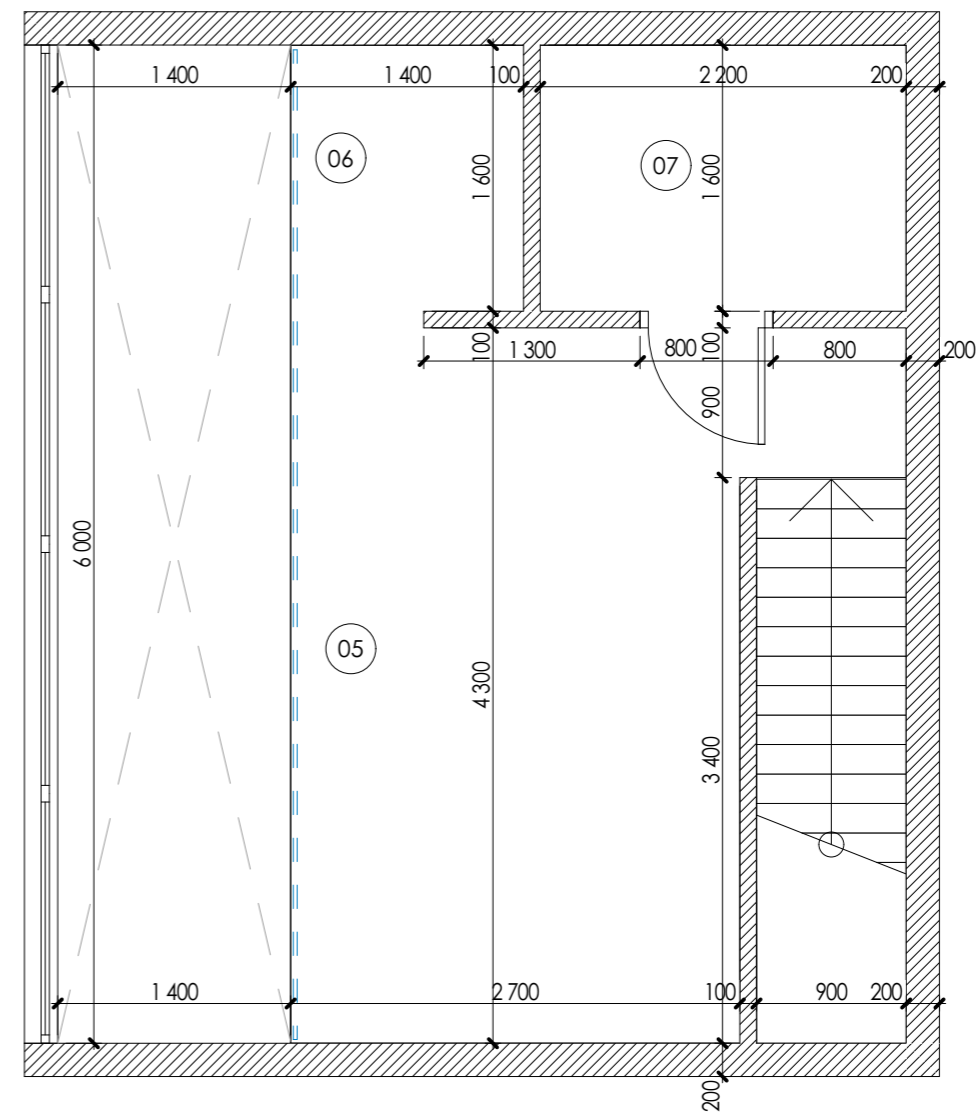

Premises specification		
No	Name	Area
01	Hall	1,64
02	Living/kitchen/dining	22,19
03	Toilet room	2,59
04	Stairs	3,78

Premises specification		
No	Name	Area
05	Bedroom	12,51
06	Wardrobe	2,32
07	Bathroom	3,52
		48,55 m²

Note:

1. The contractor develops detailed drawings and coordinates the content and dimensions with the architect of the project.
2. All dimensions are design. Before ordering, manufacturing, installation of furniture, it is imperative to perform actual measurements.
3. The color and texture of the materials are agreed only on real samples.
4. In case of changes in dimensions or position in space, coordinate with the project architect.

Measurement layout

Scale
1:50


Sheet
2.1

Architect:


SNAAR

Furniture layout

Ground floor

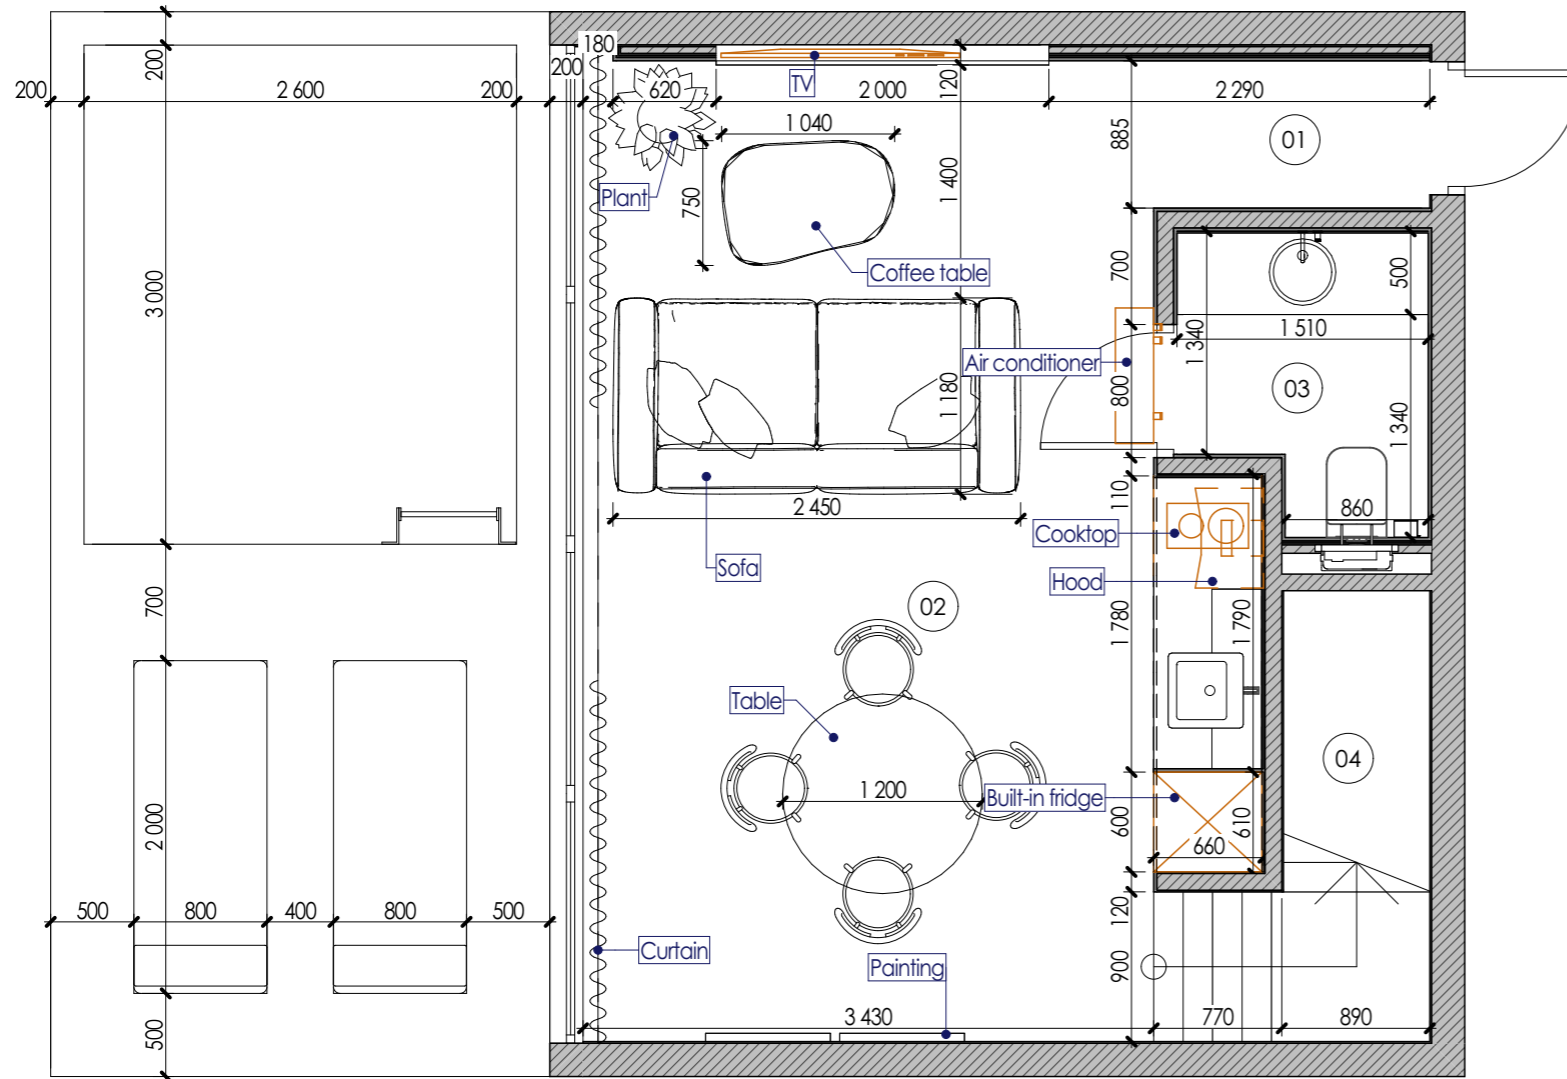

First floor

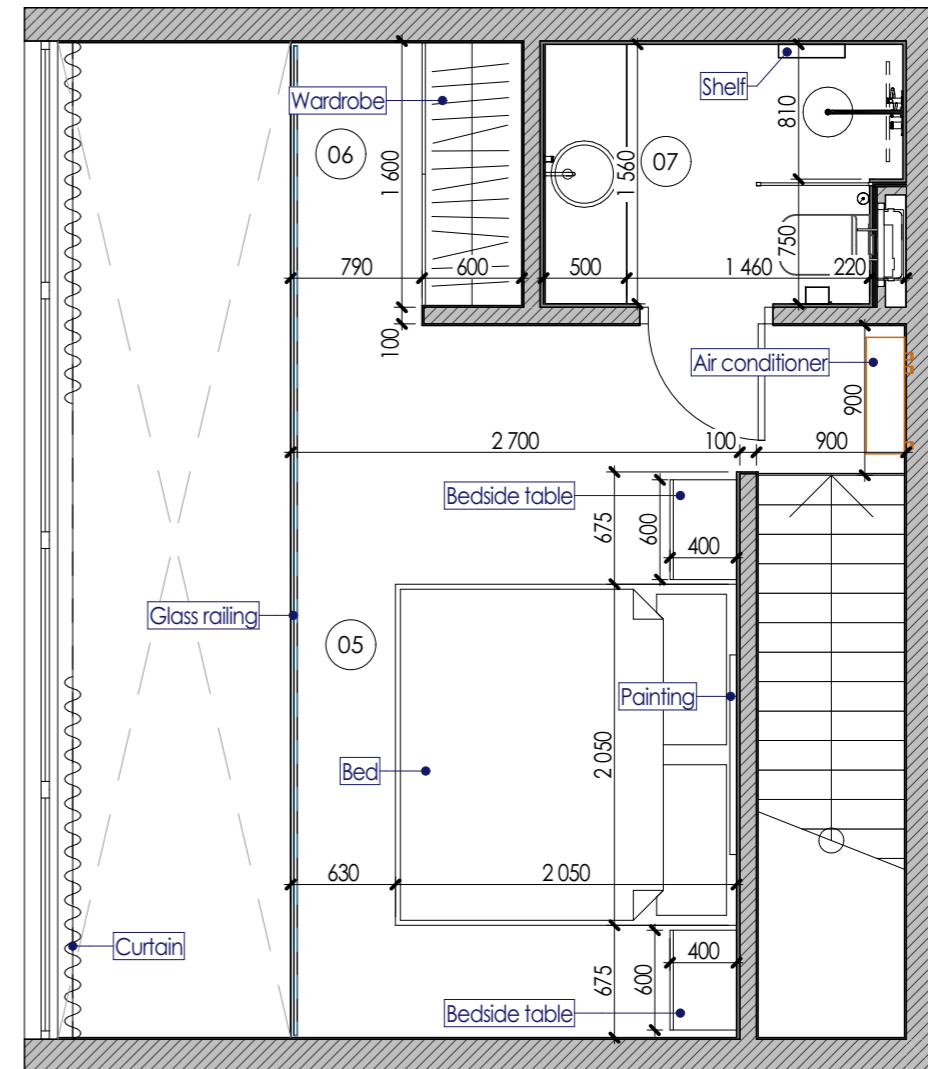

Note:

1. The contractor develops detailed drawings and coordinates the content and dimensions with the architect of the project.
2. All dimensions are design. Before ordering, manufacturing, installation of furniture, it is imperative to perform actual measurements.
3. The color and texture of the materials are agreed only on real samples.
4. Dimensions with * to be specified in fact.
5. In case of changes in dimensions or position in space, coordinate with the project architect.

Premises specification		
No	Name	Area
01	Hall	1,64
02	Living/kitchen/dining	22,19
03	Toilet room	2,59
04	Stairs	3,78

Premises specification		
No	Name	Area
05	Bedroom	12,51
06	Wardrobe	2,32
07	Bathroom	3,52
		48,55 m²

Furniture layout

Scale
1:50


Sheet
2.2

Architect:


SNAAR

Plan of binding sanitary equipment

Ground floor fragment

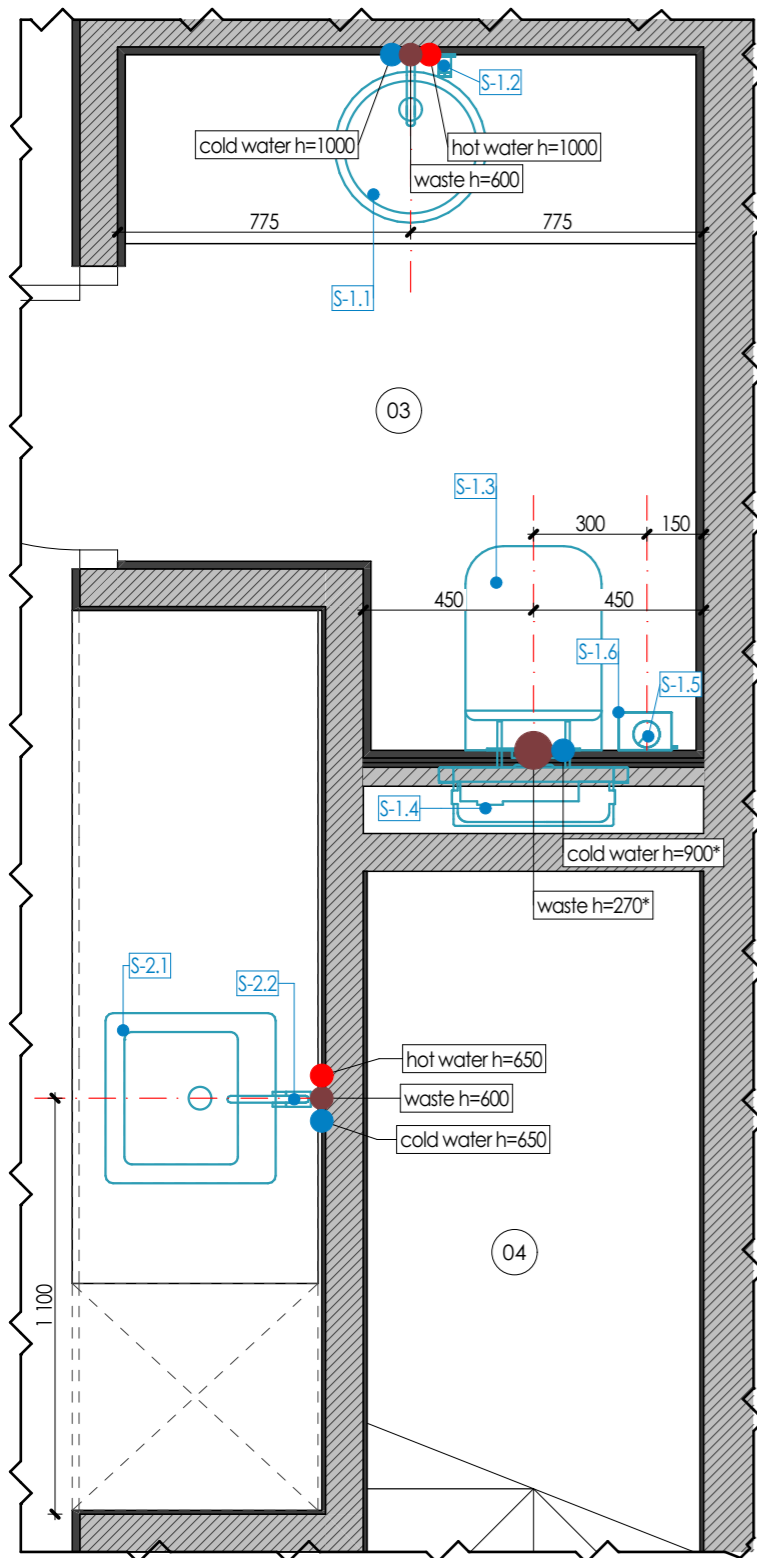

First floor fragment


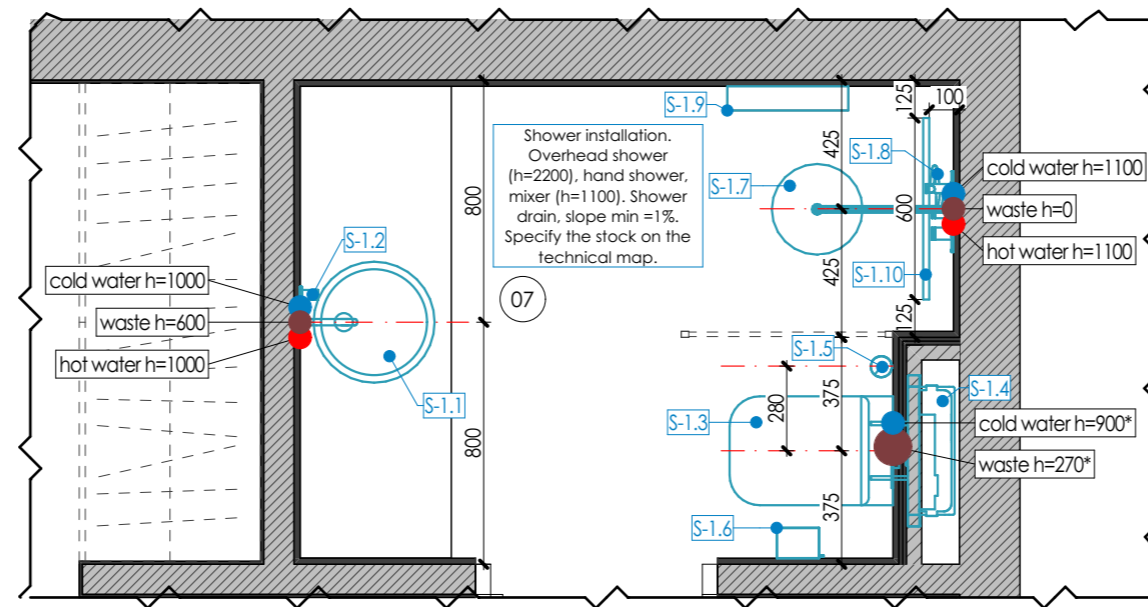


Premises specification		
№	Name	Area
01	Hall	1,64
02	Living/kitchen/dining	22,19
03	Toilet room	2,59
04	Stairs	3,78

Premises specification		
№	Name	Area
05	Bedroom	12,51
06	Wardrobe	2,32
07	Bathroom	3,52
		48,55 m²

Legend:

- Cool water output
- Hot water output
- Waste output

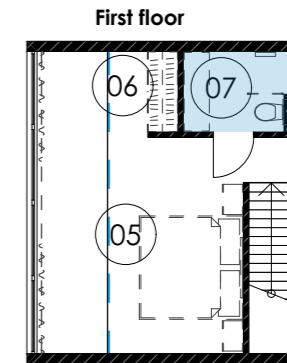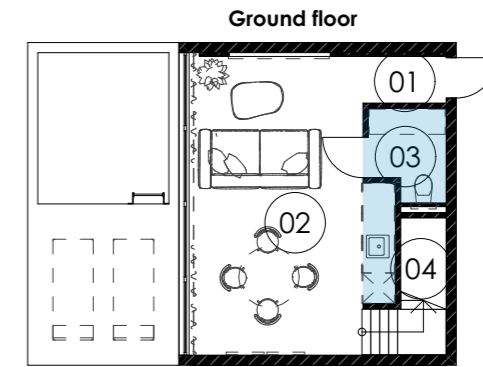

Sanitary equipment specification			
№	2D	Name	Amount
S-1.1		Washbasin	2
S-1.2		Washbasin tap	2
S-1.3		Toilet	2
S-1.4		Toilet installation	2
S-1.5		Toilet brush holder	2
S-1.6		Toilet paper holder	2
S-1.7		Overhead shower	1
S-1.8		Shower taps	1
S-1.9		Shelf	1
S-1.10		Drain	1
S-2.1		Kitchen sink	1
S-2.2		Kitchen tap	1
			18

Note:

1. Dimensions do not include plaster and wall finishes from the level of the finished floor 0.000 to the center of the faucet or the planned water consumer, the dimensions must be clarified upon actual
2. Check water and sewer connections after alignment walls, as well as to clarify according to the technical cards of approved plumbing fixtures
3. Models of sanitary equipment can be specified during the design process
4. All inspection hatches of concealed installation in the finish of the wall on which they are located (specify the location)
5. Dimensions with * must be specified in fact

Plan of binding sanitary equipment

Scale 1:50


Sheet 3.1

Architect:


SNAAR



Ceiling layout

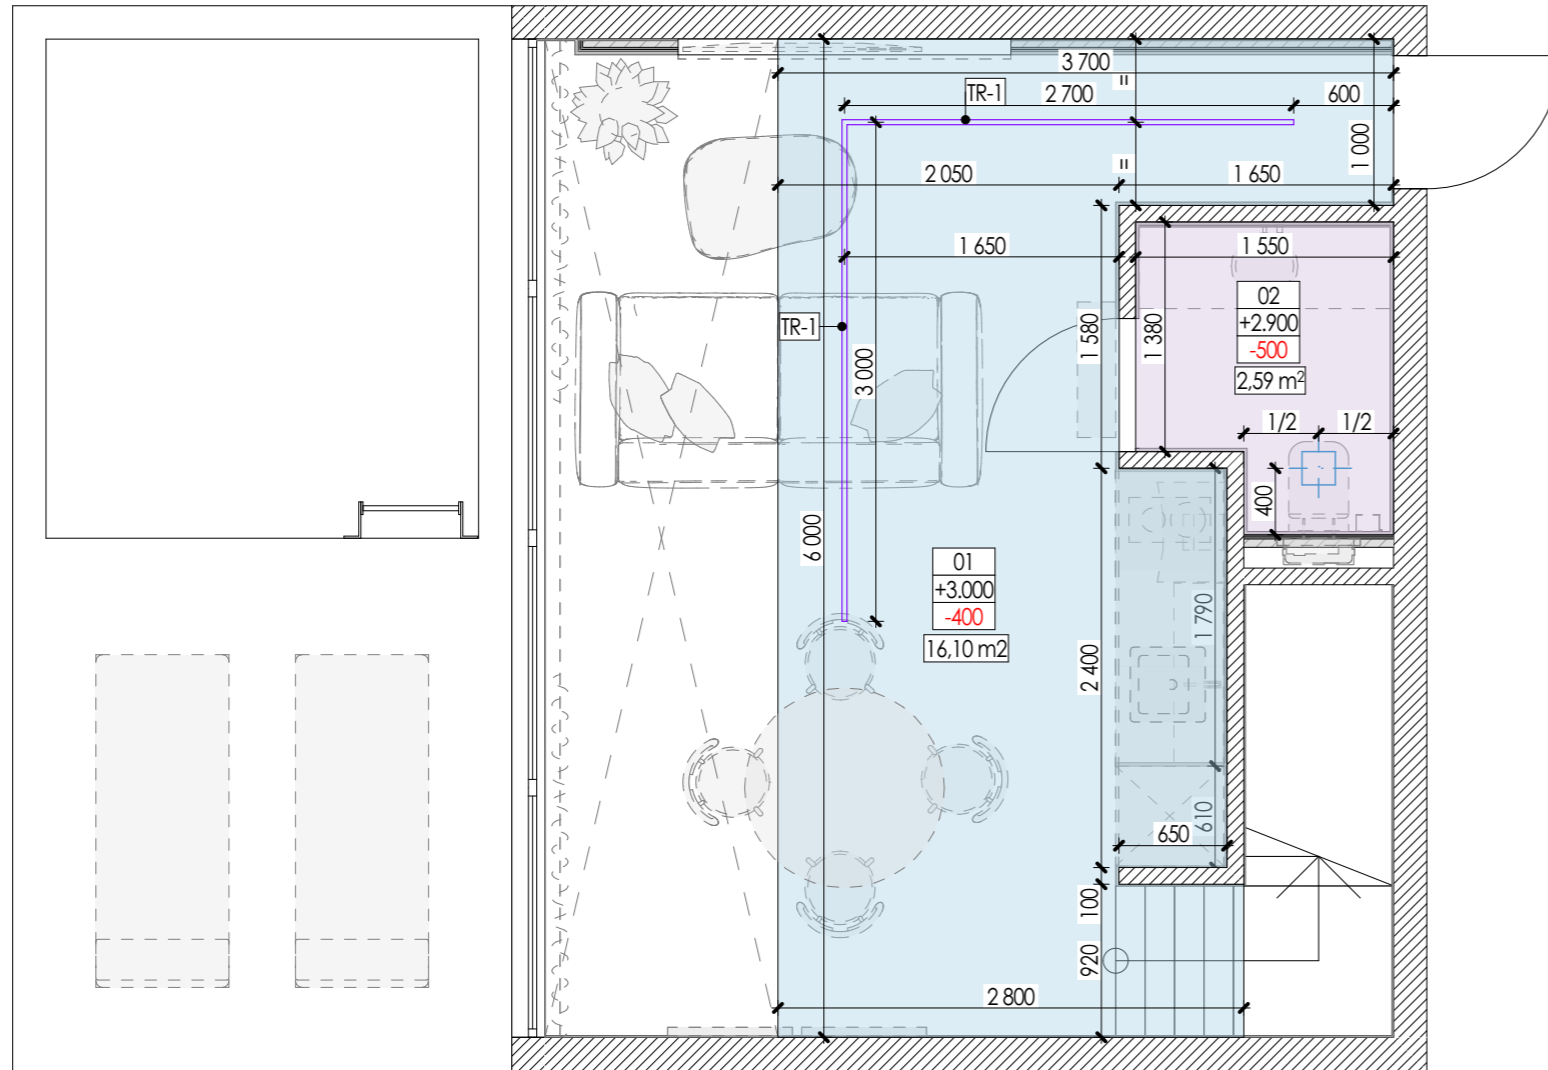Ground floor

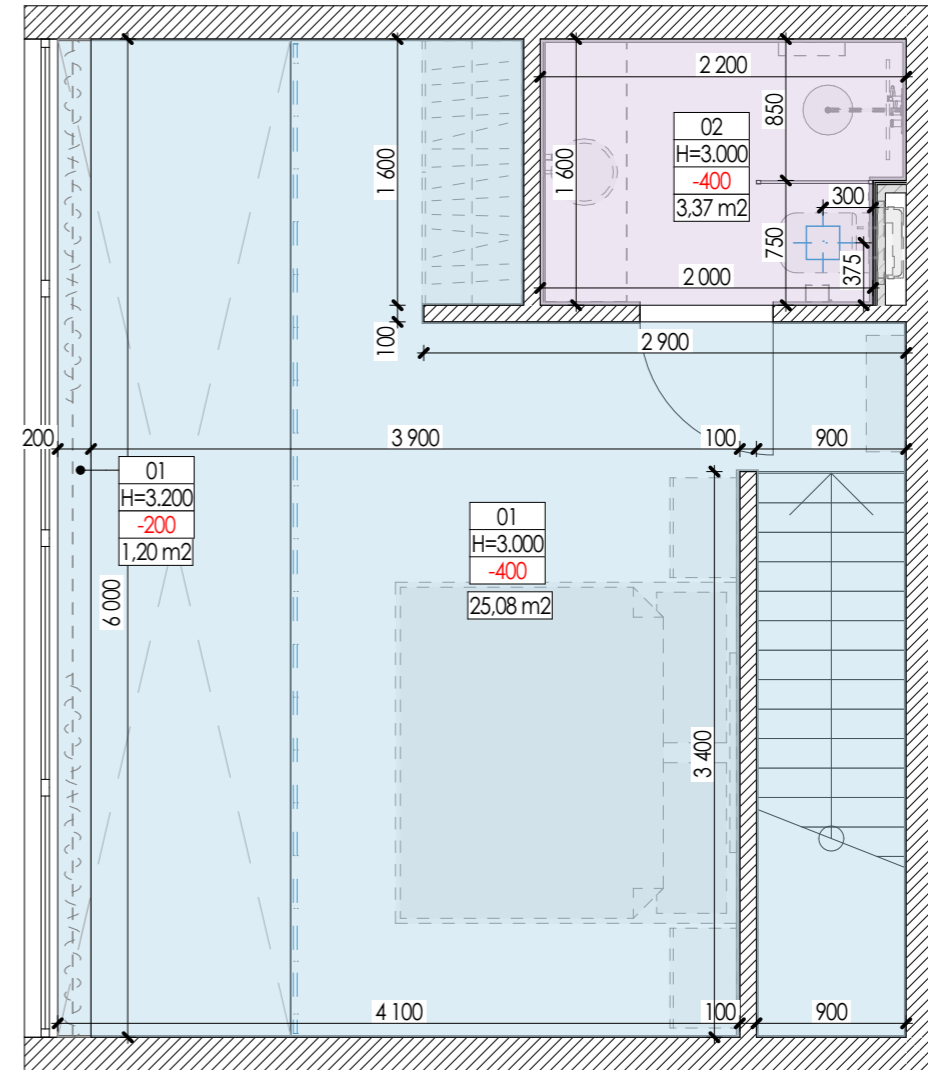

First floor



Ceiling coverings specification				
ID	D	Type of construction	Area	Covering
01		Suspended ceiling. 1 drywall sheet 12,5mm on metal frame	42,55	Painting RAL 9001
02		Suspended ceiling. 1 drywall sheet 12,5mm on metal frame	5,96	Waterproof Painting RAL 9001
			48,51 m ²	

Legend:



-Ventilation grate for hidden installation

Note:

1. Ceiling covering - plaster, painting. Coordinate the color with samples on the object with the designer.
2. Areas are indicated without calculation for pruning and stock. Recommended margin - 15%
4. Important. in the place intended for fastening curtains, provide for a cornice, model, dimensions and bindings to agree
5. Dimensions are indicated without plaster and wall decoration

Ceiling layout

Scale
1:50


Sheet
5.2

Architect:


SNAAR

Lights layout

Ground floor

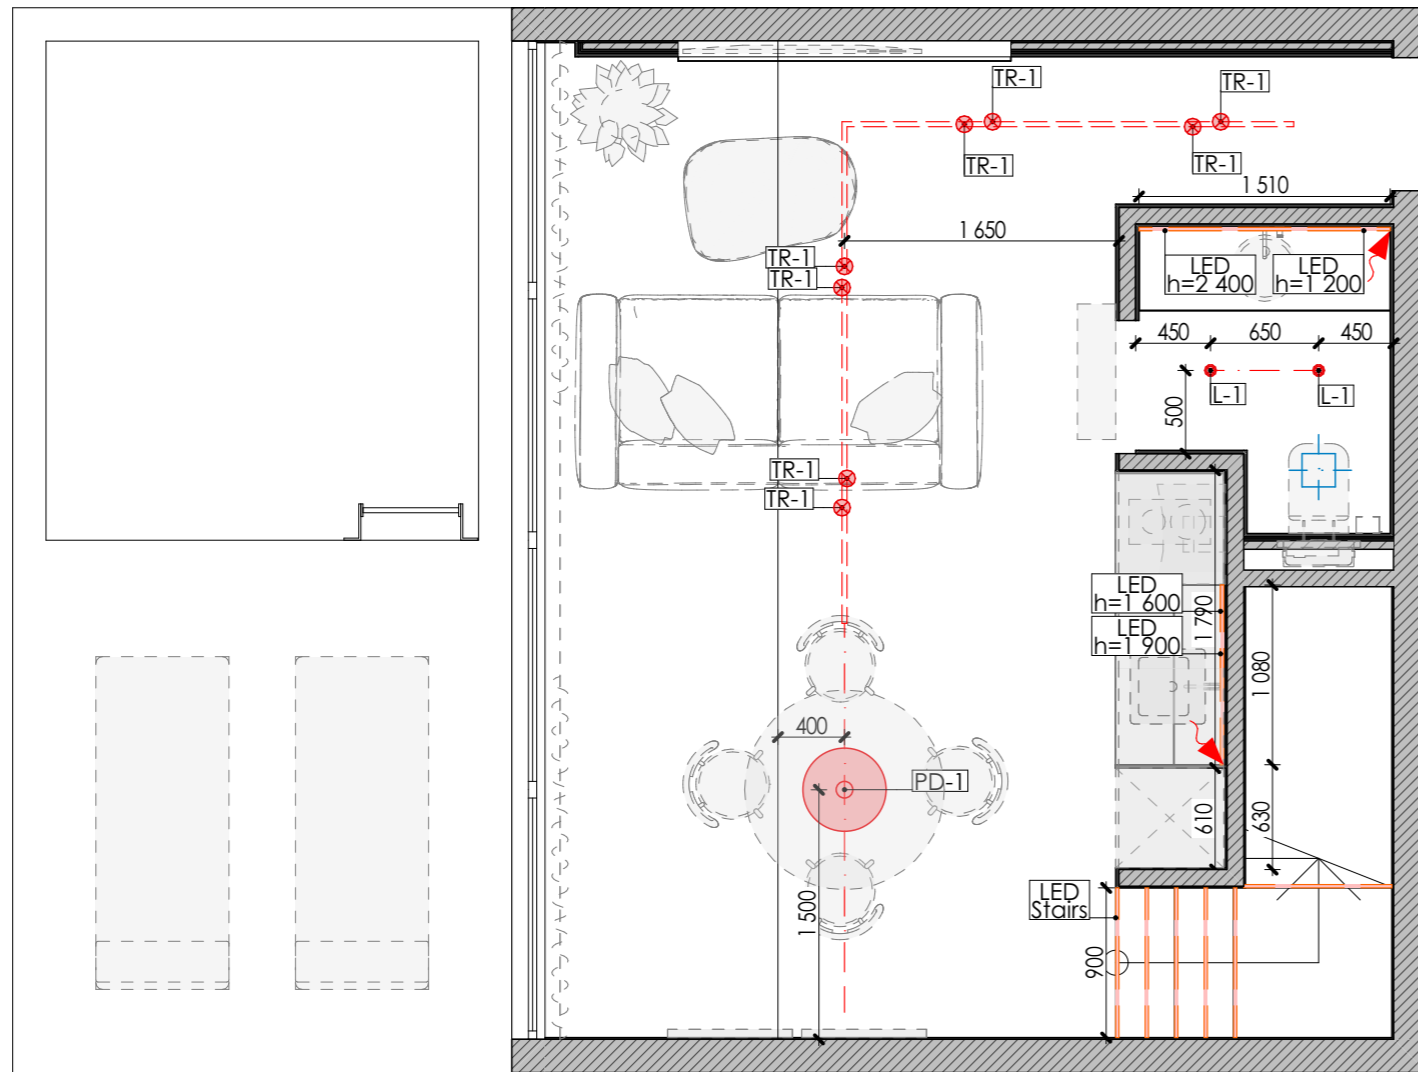

First floor

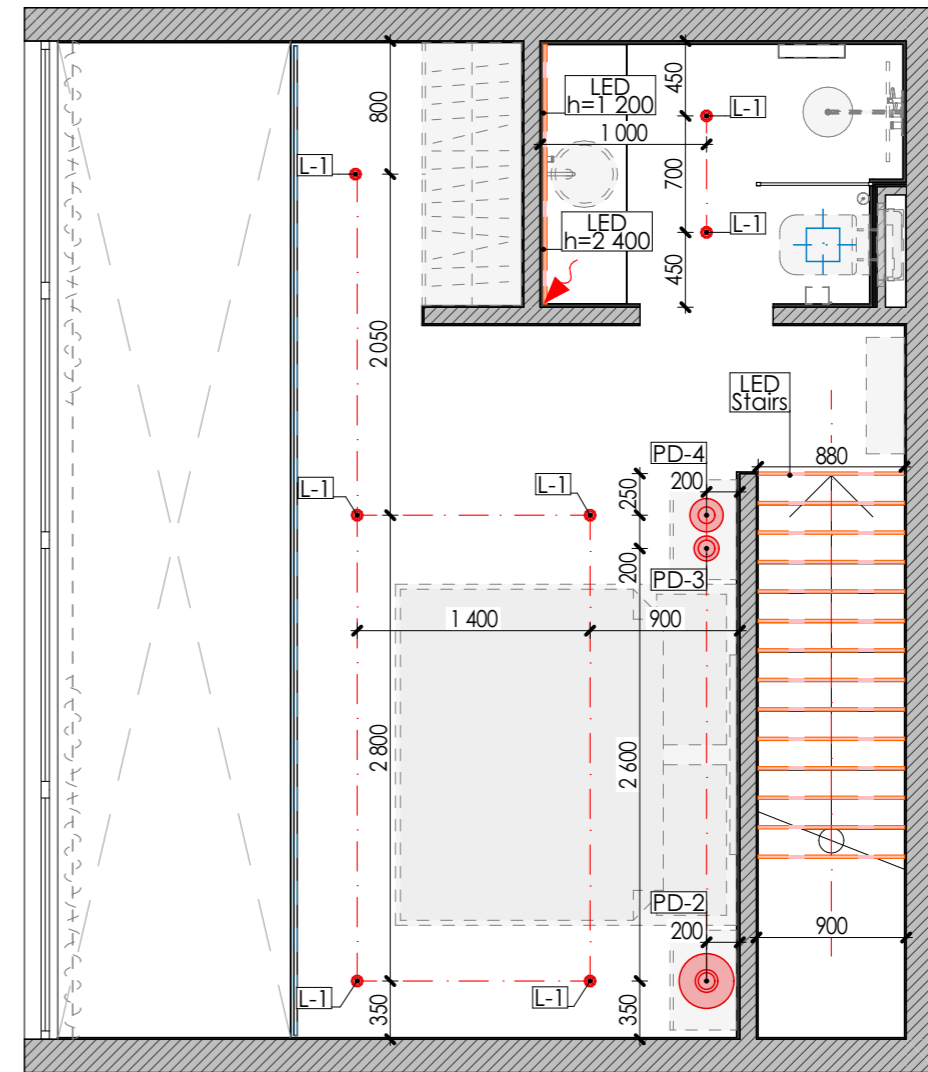


Note:

1. Bindings to lighting equipment are indicated to the center of the device
2. Luminaires and outlets without a specified height are located on the ceiling
3. Lengths are without stock
4. The LED count is excluding lights in cabinets, behind mirrors and under steps (calculated when ordering furniture)
5. Plan to be considered together with sheets "Ceiling plan", "Lighting group layout"

Lights specification				
ID	2D	Type	Amount	Visualisation
L-1		Built-in dot light	9	
PD-1		Pendant lamp	1	
PD-2		Pendant lamp	1	

Lights specification				
ID	2D	Type	Amount	Visualisation
PD-3		Pendant lamp	1	
PD-4		Pendant lamp	1	
TR-1		Track light	8	
			21	

Specification of LED and magnetic track				
	2D	Name	Length,mm	Visualisation
LED		LED profile	26 010	
TR-1		Magnetic track for track light	5 730	

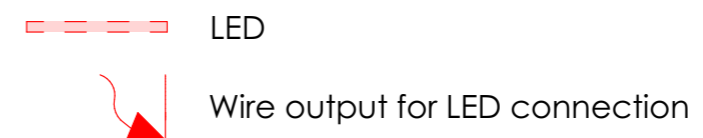

Lights layout

Scale
1:50


Sheet
6.1

Architect:


SNAAR

Groups of lights layout

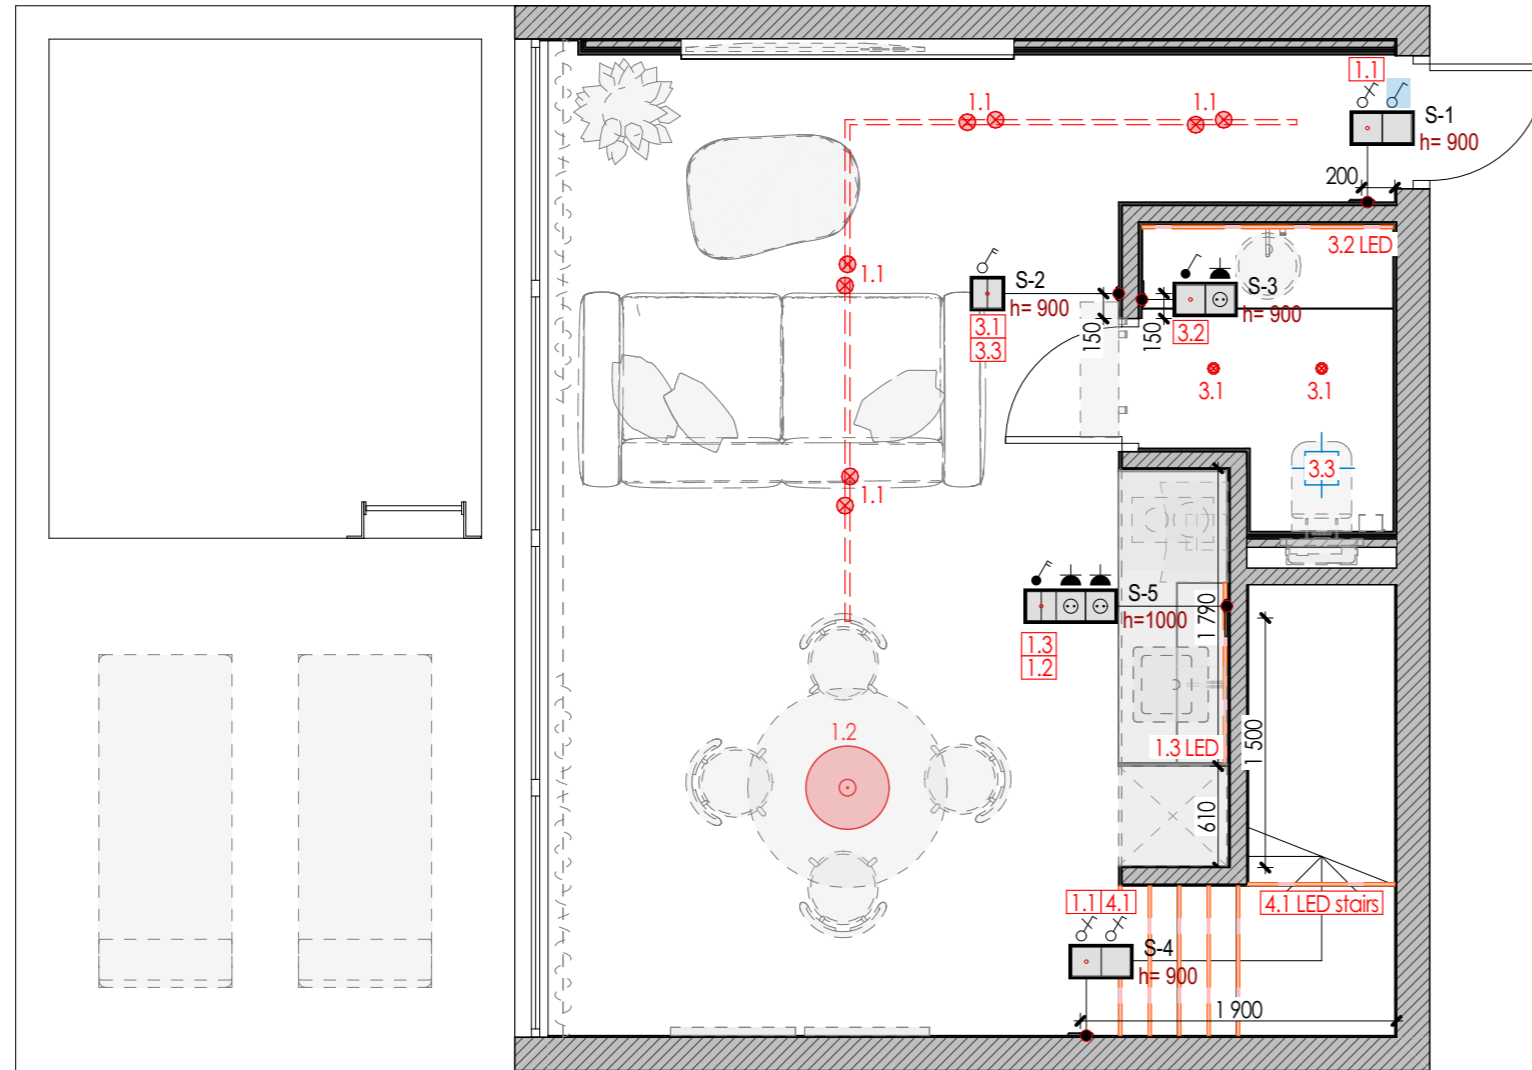


Ground floor

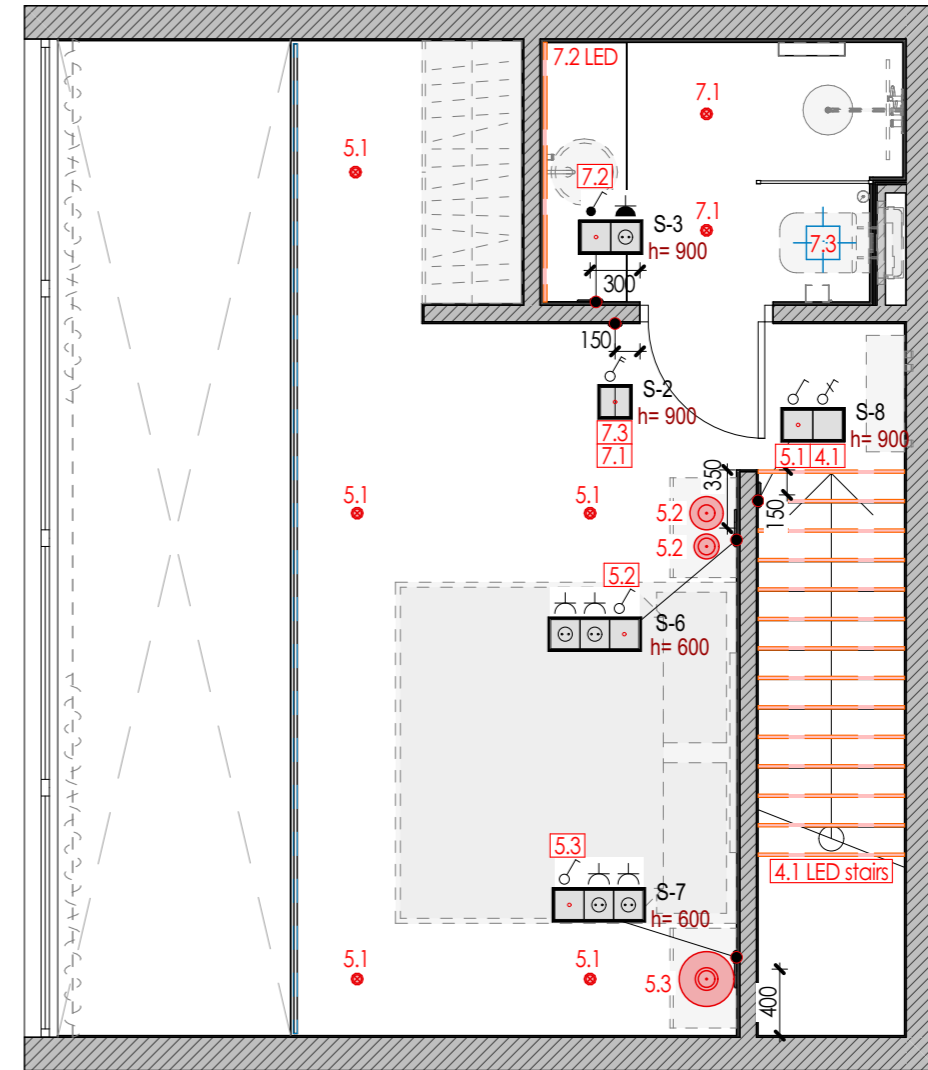

First floor

 

Legend:

-  Master switch
-  Switch IP20
-  Switch IP44

Note:

1. Dimensions are indicated to the center of the element (both in height and in width)
2. Dimensions are excluding plaster and finishes. Dimensions with * need to be specified.
3. After completing the plastering and screeding work, it is necessary to recheck the bindings.
4. Plan to be considered together with sheets "Lighting plan", "Ceiling plan" and "Switches and sockets specification"

Groups of lights layout

Scale 1:50


Sheet 6.4

Architect:


SNAAR

Sockets layout

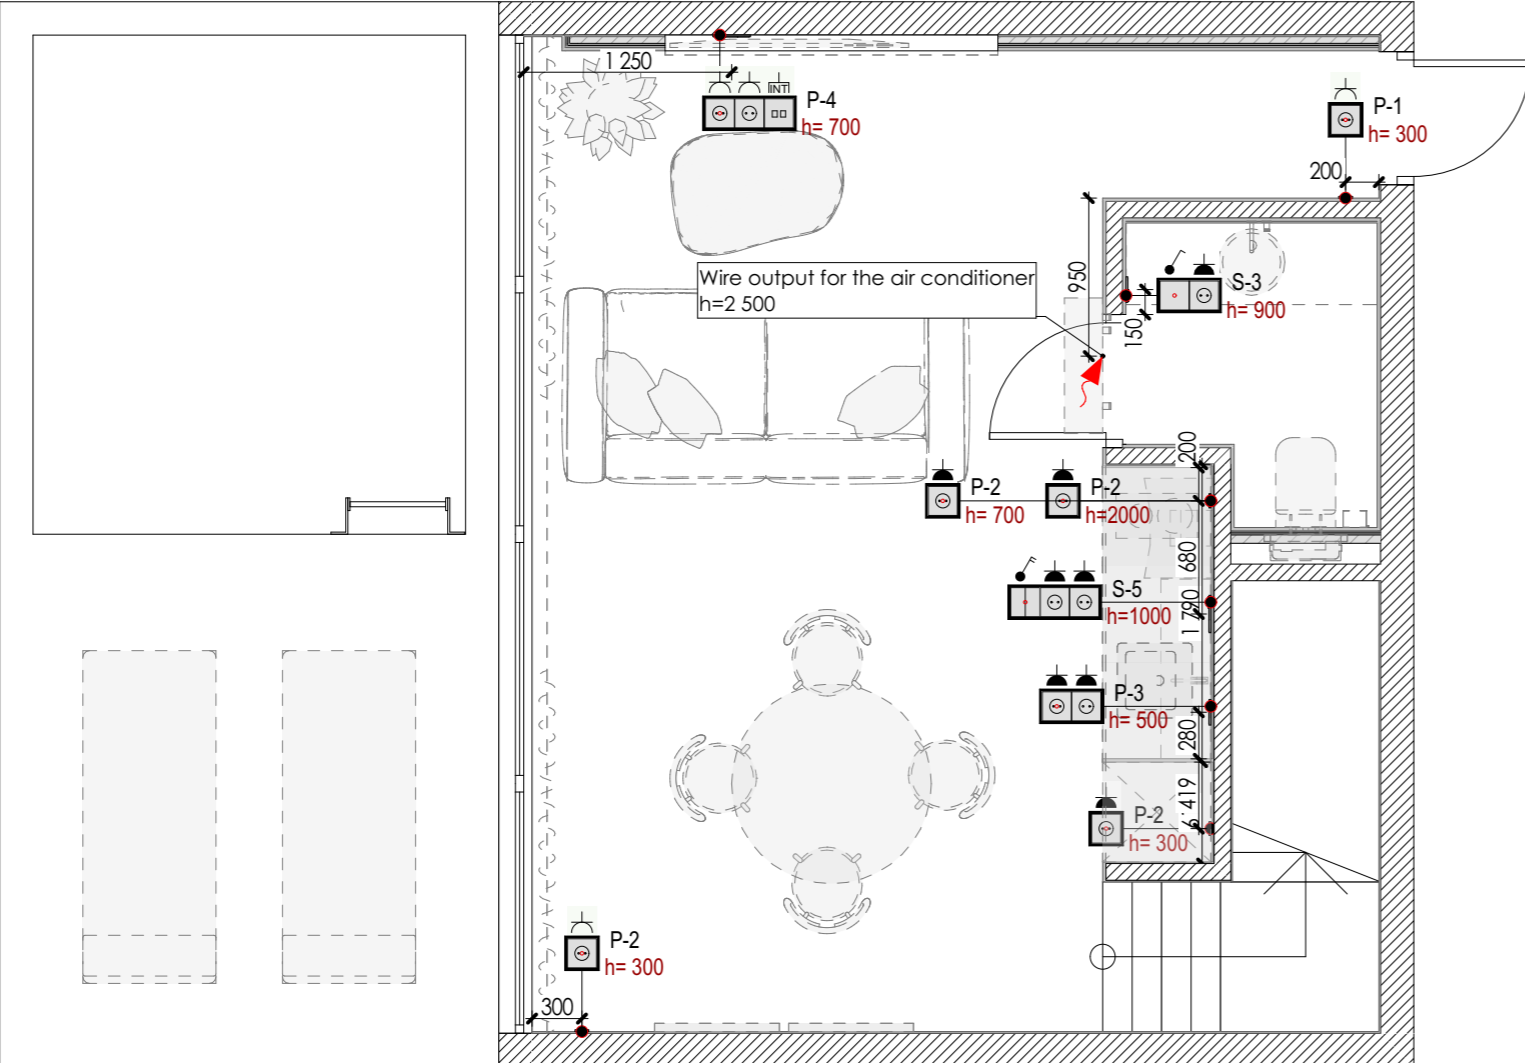


Ground floor

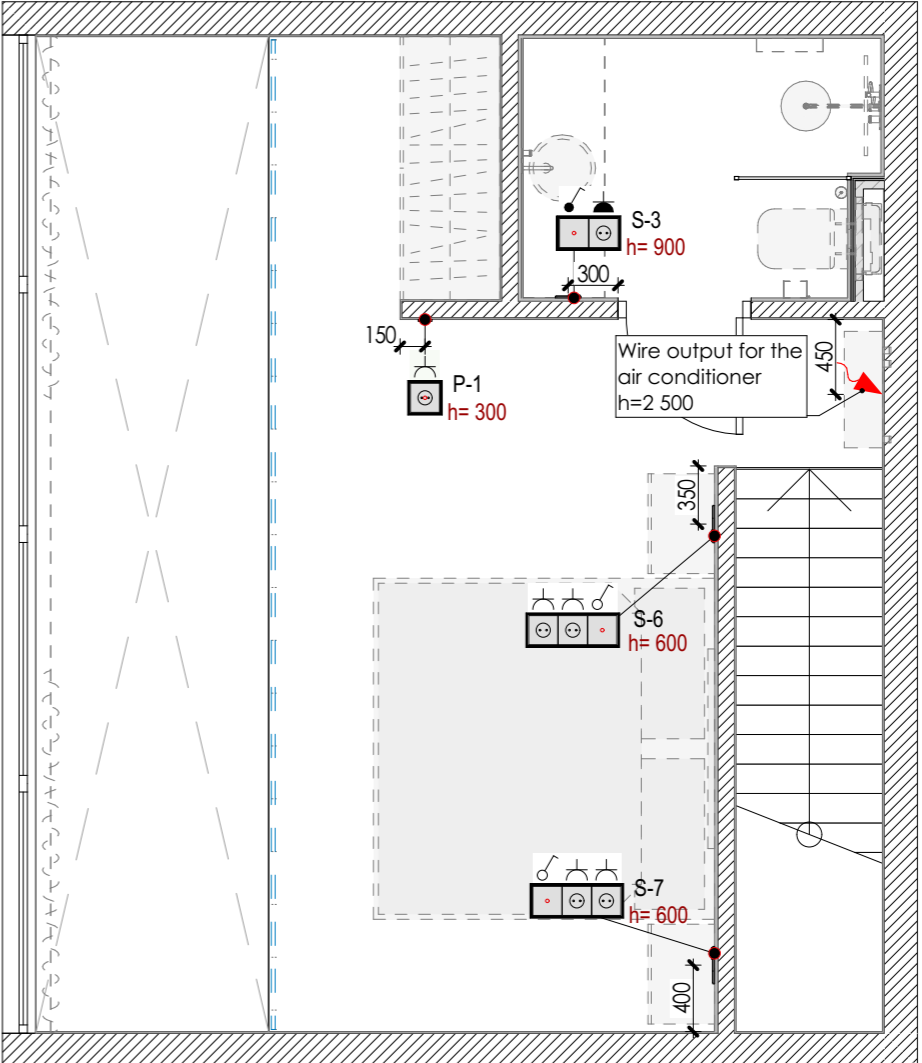

First floor



Legend:

-  Socket 220v IP44
-  Socket 220v IP20
-  Wire output 220V

Note:

1. The size is specified to the center of the element (both in height and in width)
2. Read the diagram along with 'Lighting groups layouts', and 'Switches and sockets specification'



 









Sockets layout

Scale
1:50

Sheet
6.7

Architect:

SNAAR

Specification of sockets and switches			
ID	3D	Frame filling	Amount
P-1		Socket 220V IP20	2
P-2		Socket 220V IP44	4
P-3		Sockets 220V IP44, x2	1
P-4		Sockets 220V IP20 x2, internet socket	1
S-1		One key through switch, master switch	1
S-2		Two key switch	2
S-3		One key switch IP44, socket 220V IP44	2
S-4		One key through switch x2	1
S-5		Two key switch, sockets 220V IP44 x2	1
S-6		One key switch, sockets 220V IP20 x2	1
S-7		Sockets 220V IP20 x2, One key switch,	1
S-8		One key switch, One key through switch	1
			18

Note:

1. Approve with electrician.
2. In case of changes in dimensions or position in space, coordinate with the project architect.

Switches and Sockets specification

Scale
1:50

Sheet
6.10


Architect:

SNAAR


Wall decoration layout

Note:

Ground floor

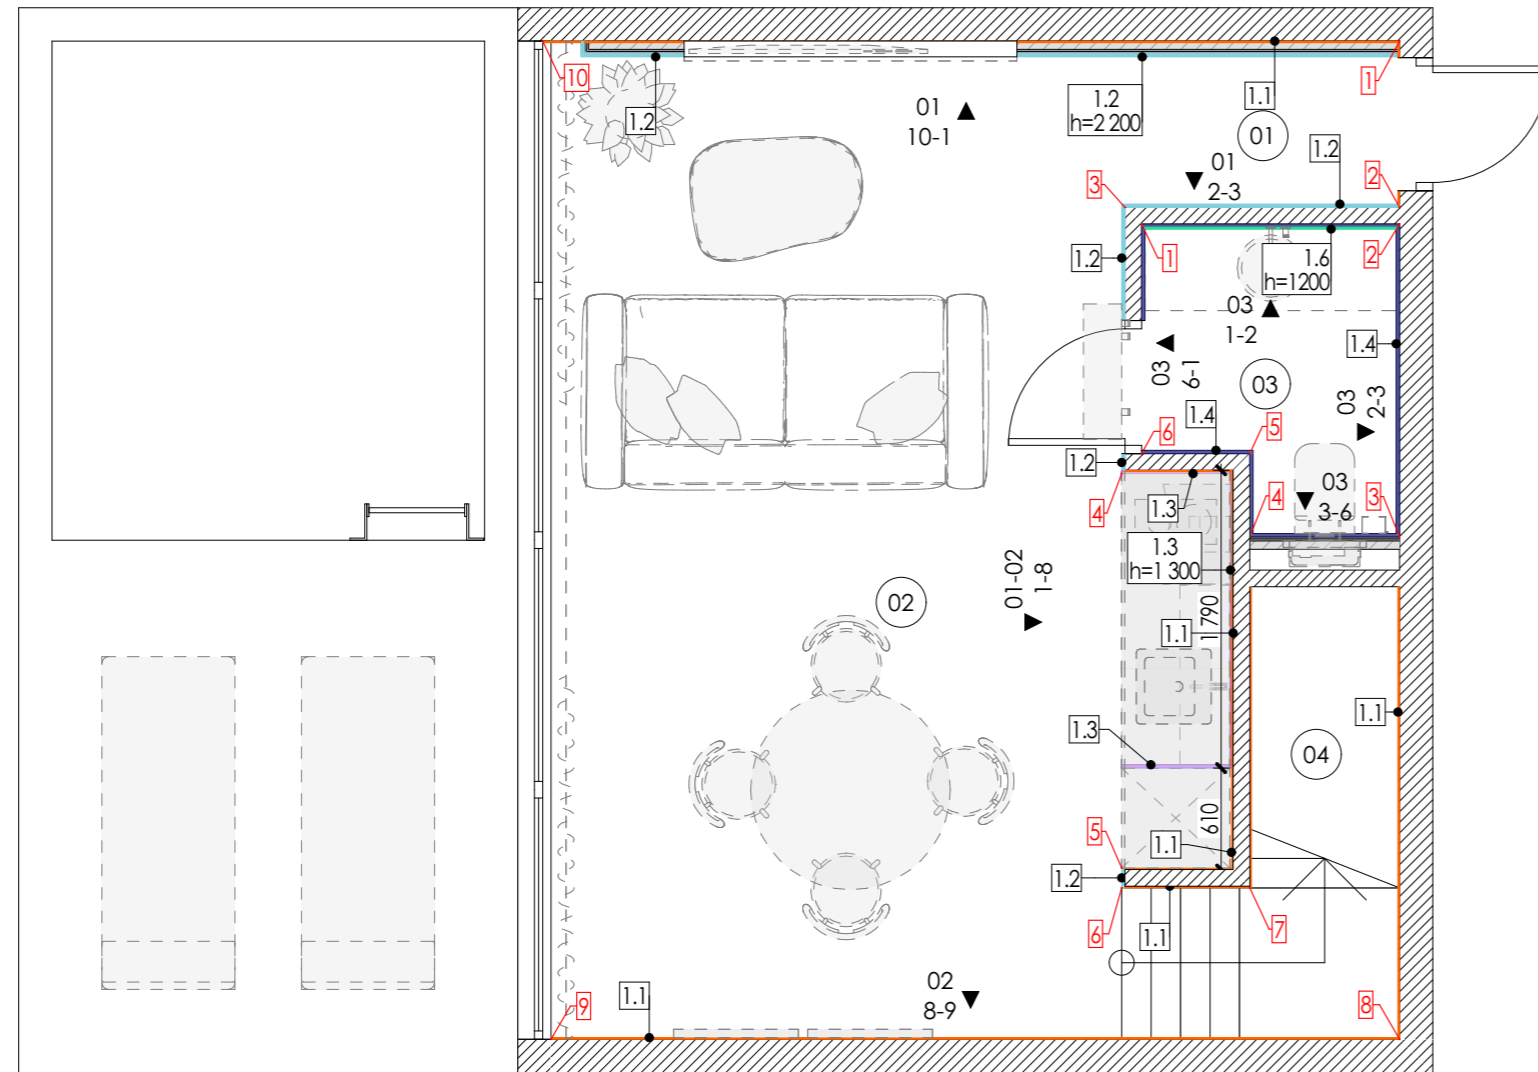

First floor

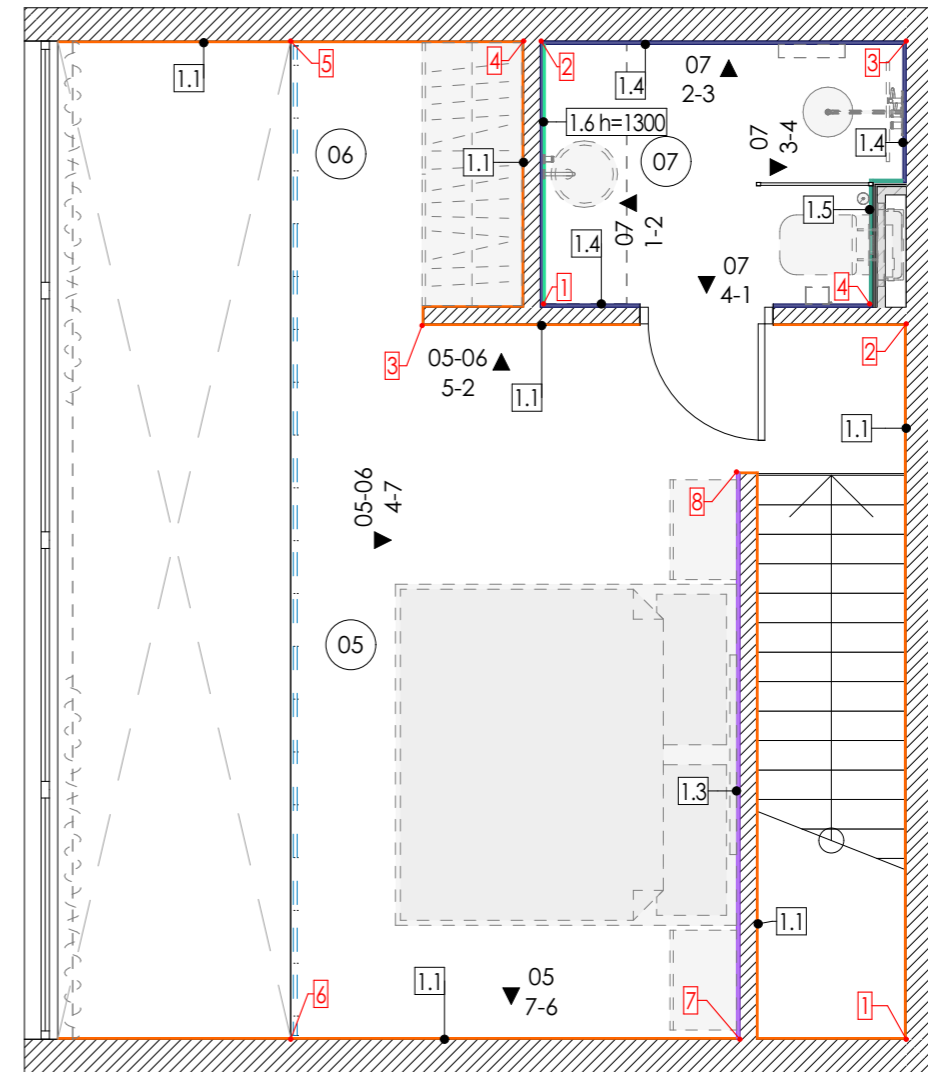

Legend:

1.1 - ID of the covering

Wall coverings specification					
ID	2D	Name of covering	Area m2	%	Area with margin
1.1		Painting RAL 9001	112,04	10	123,23
1.2		MDF panel (wood)	17,56	10	19,32
1.3		Ceramic granite tile (travertine imitation)	14,24	10	15,65

Wall coverings specification					
ID	2D	Name of covering	Area m2	%	Area with margin
1.4		Ceramic granite Tile 600x600 (beige)	36,63	10	40,30
1.5		Ceramic granite tile 50x300(turquoise)	2,79	10	3,07
1.6		Mirror	3,68	10	4,05
			186,94 m²		205,62 m²

Wall decoration layout


Scale 1:50

Sheet 7.1


Architect:

SNAAR

01 10-1

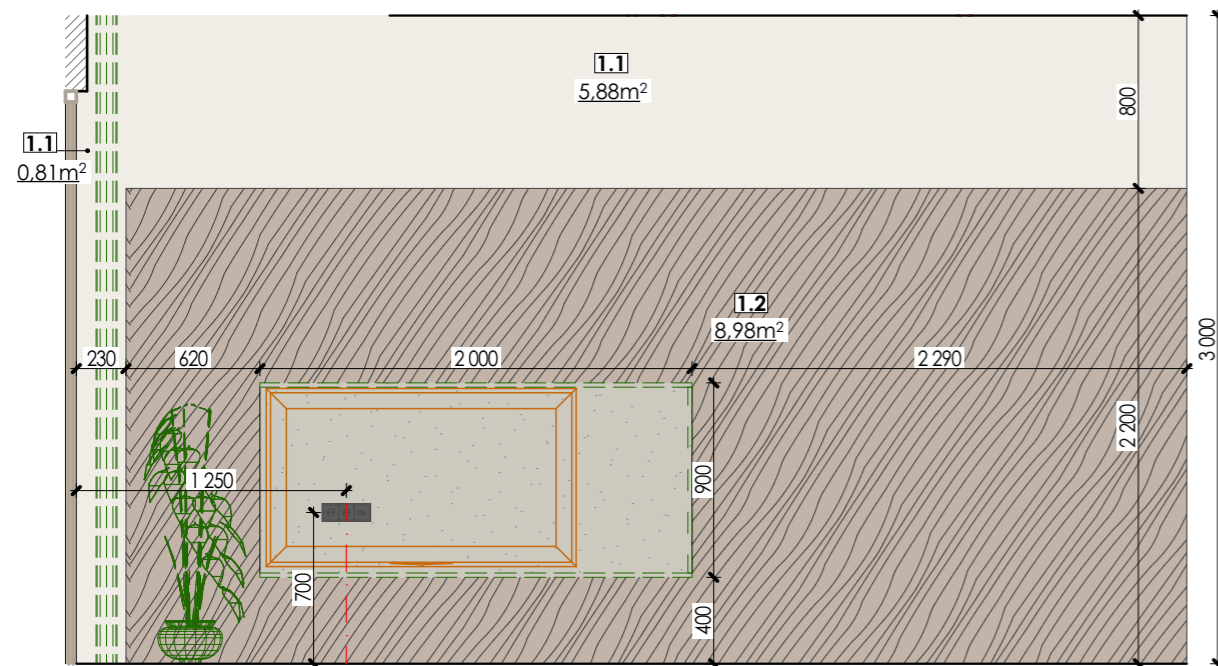

01 2-3

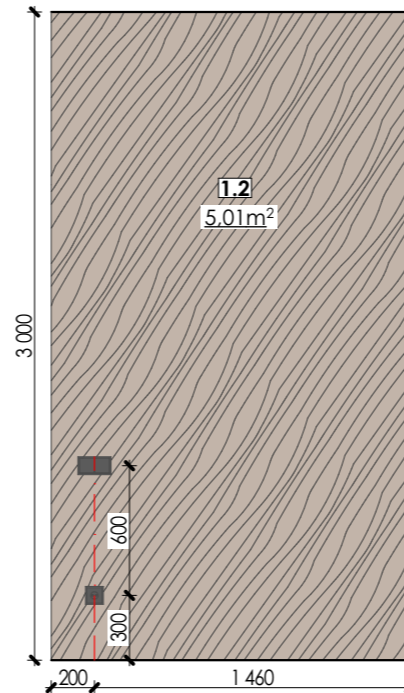


Note:



1. All dimensions are to be specified on the spot.
2. Notify the architect of all discrepancies.
3. Colours of the coverings are shown approximately.

01-02

01-02 1-8

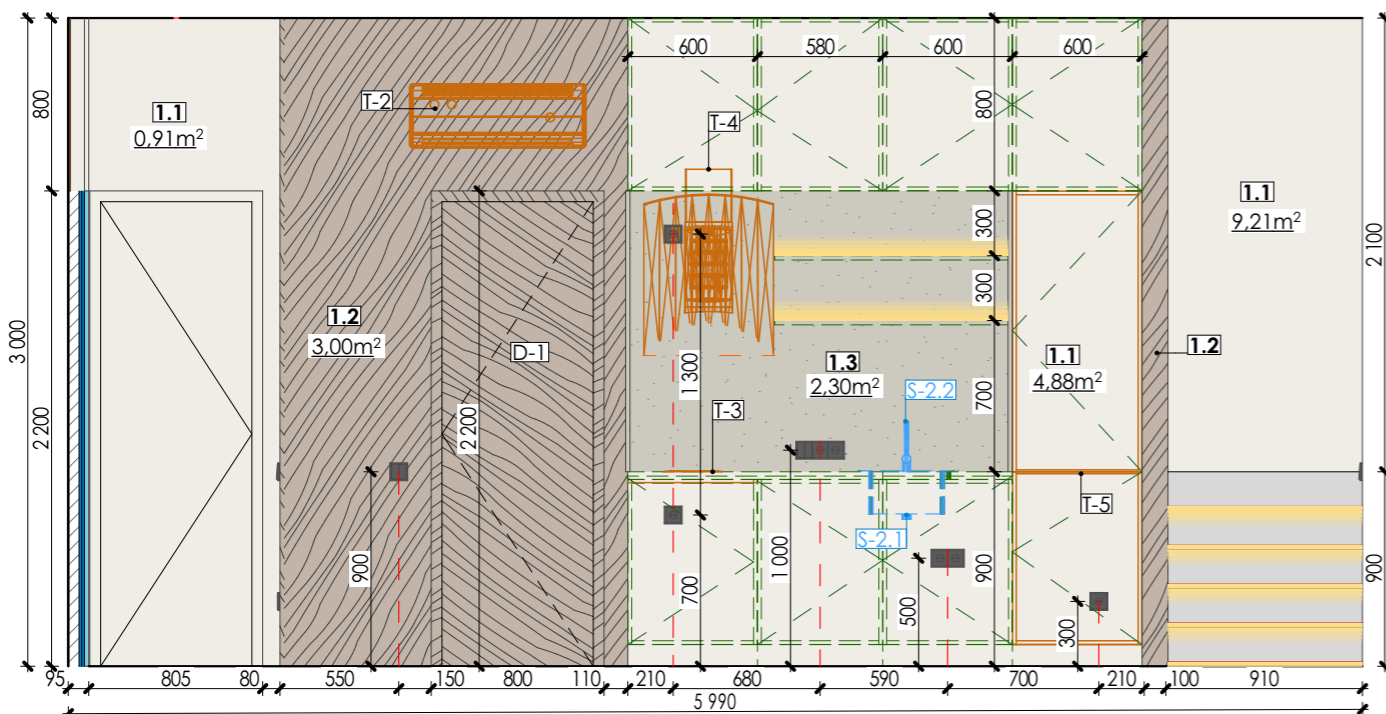

02 8-9

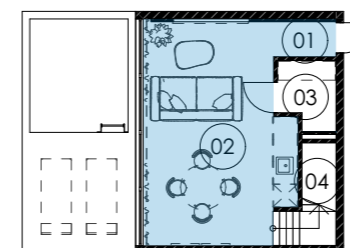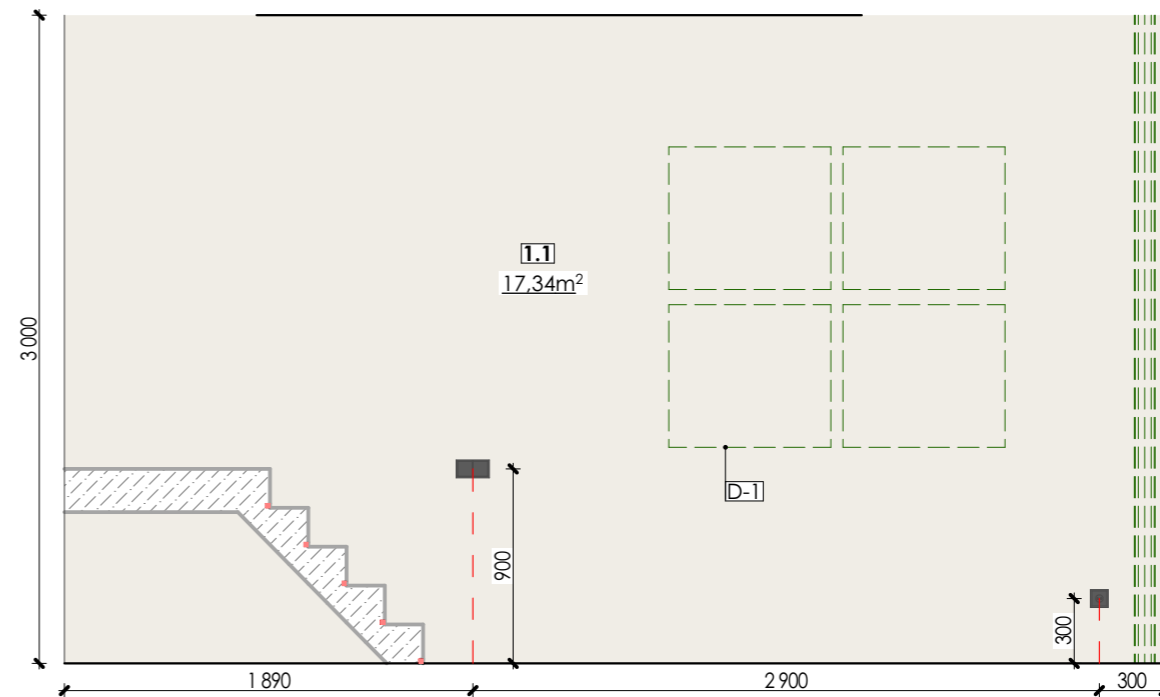

Legend:

- LED

- ID of the covering

Elevation layout 1

Scale
1:50






Sheet
7.2

Architect:

SNAAR

Note:

1. All dimensions are to be specified on the spot.
2. Notify the architect of all discrepancies.
3. Colours of the coverings are shown approximately.

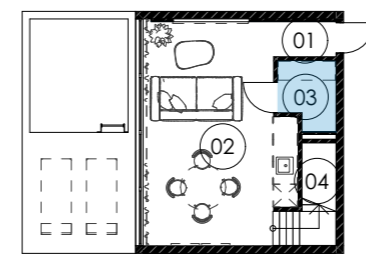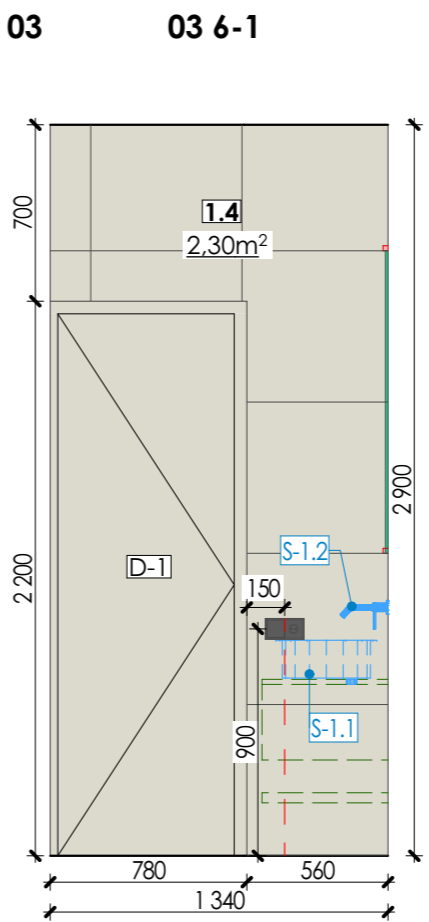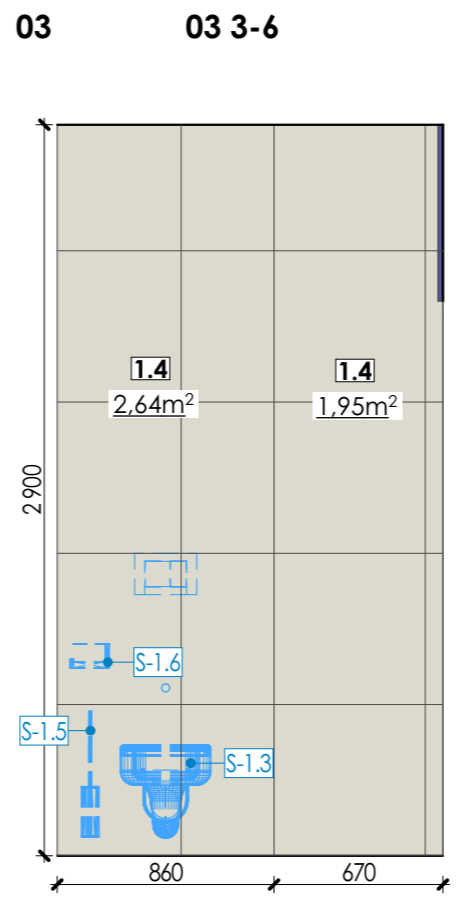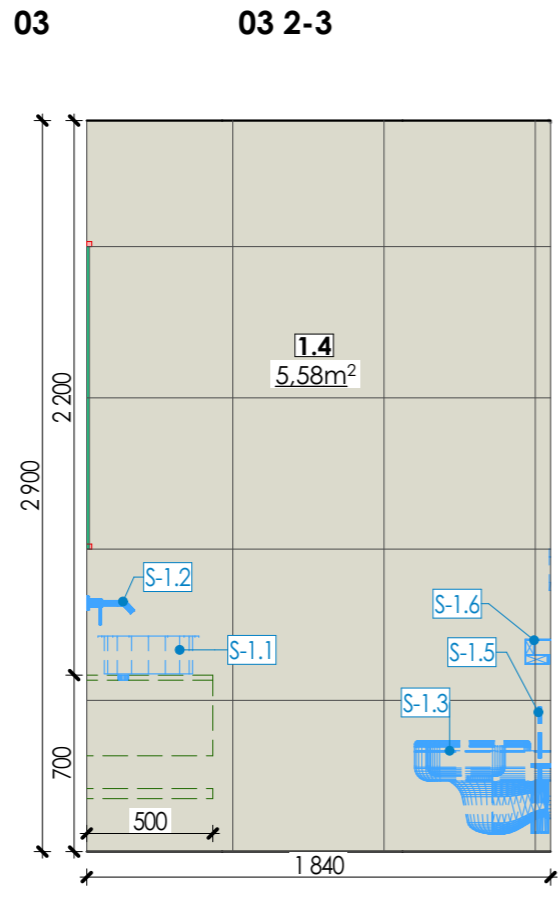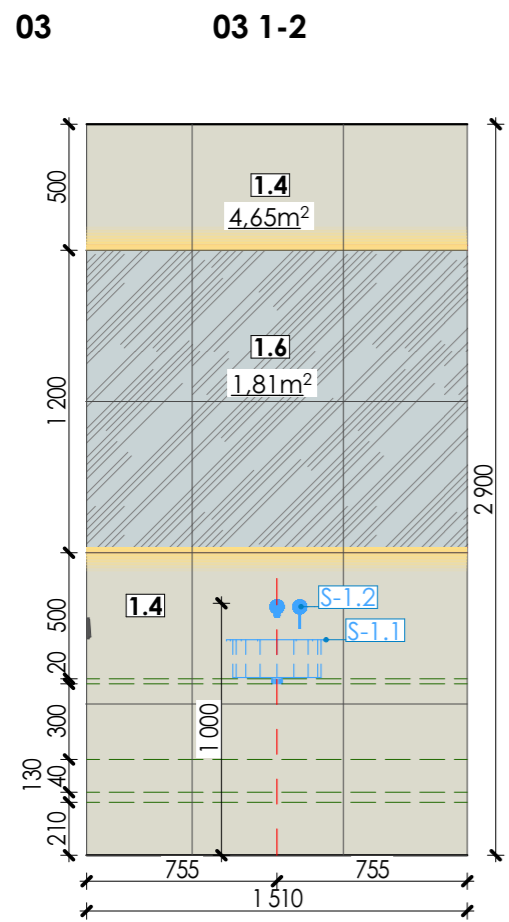

Legend:

- LED

- ID of the covering

Elevation layout 2


Scale
1:50

Sheet
7.3


Architect:

SNAAR



05-06 4-7

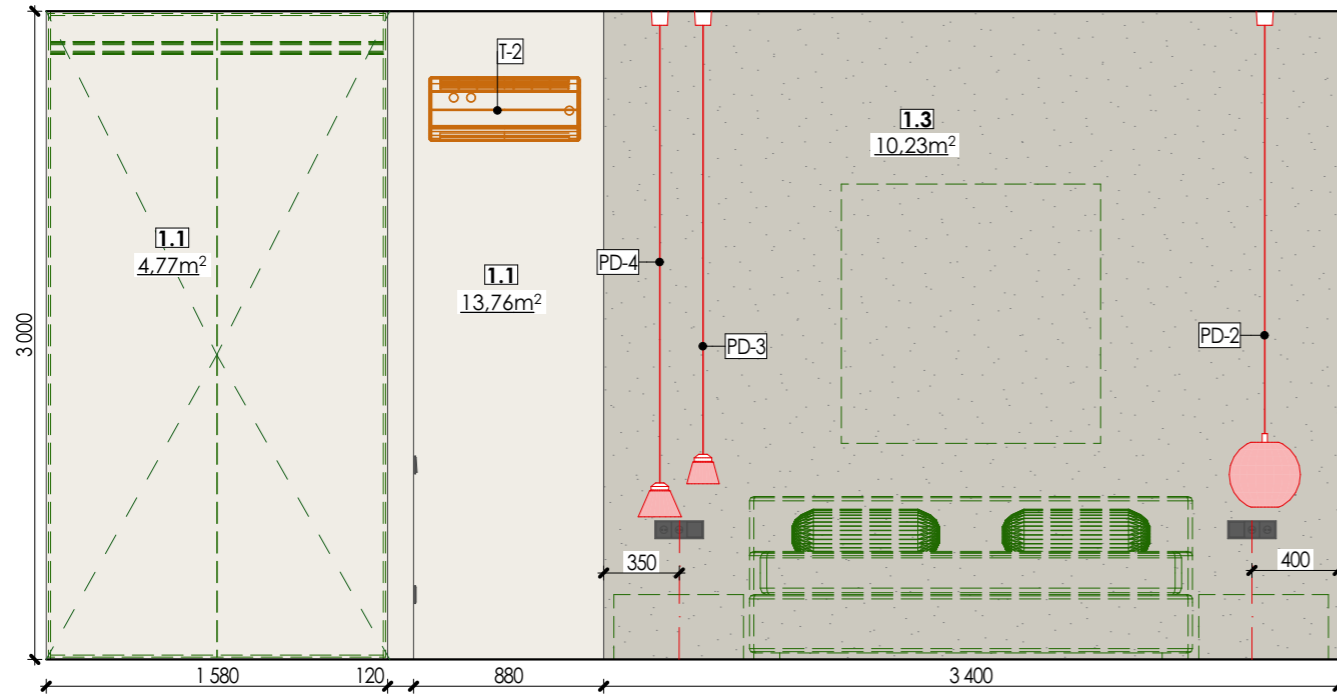

05 7-6

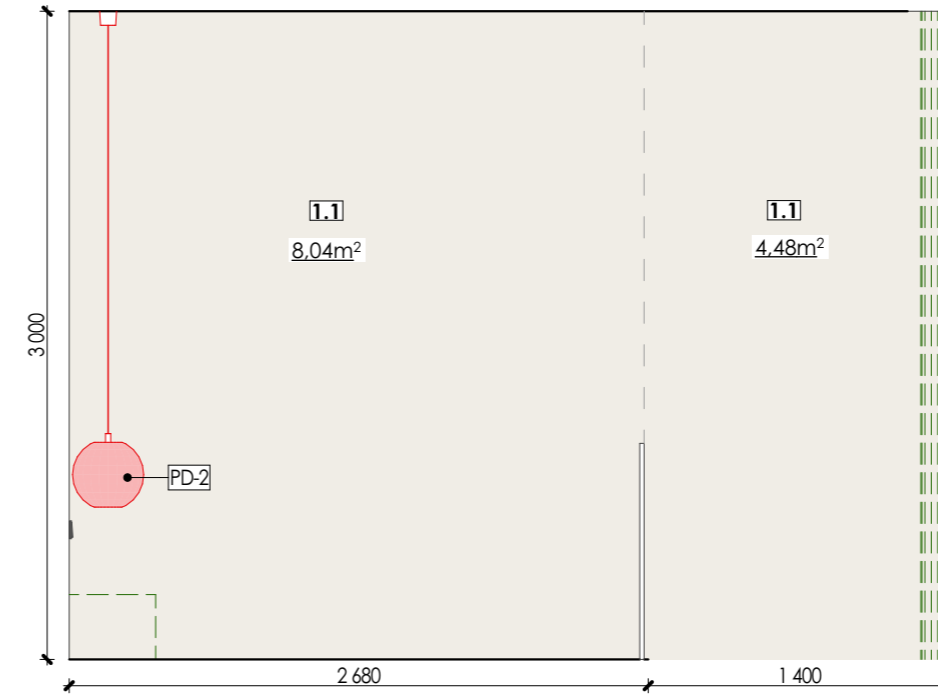

05-06 5-2

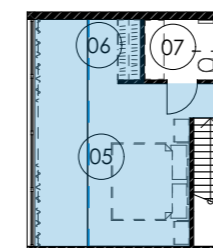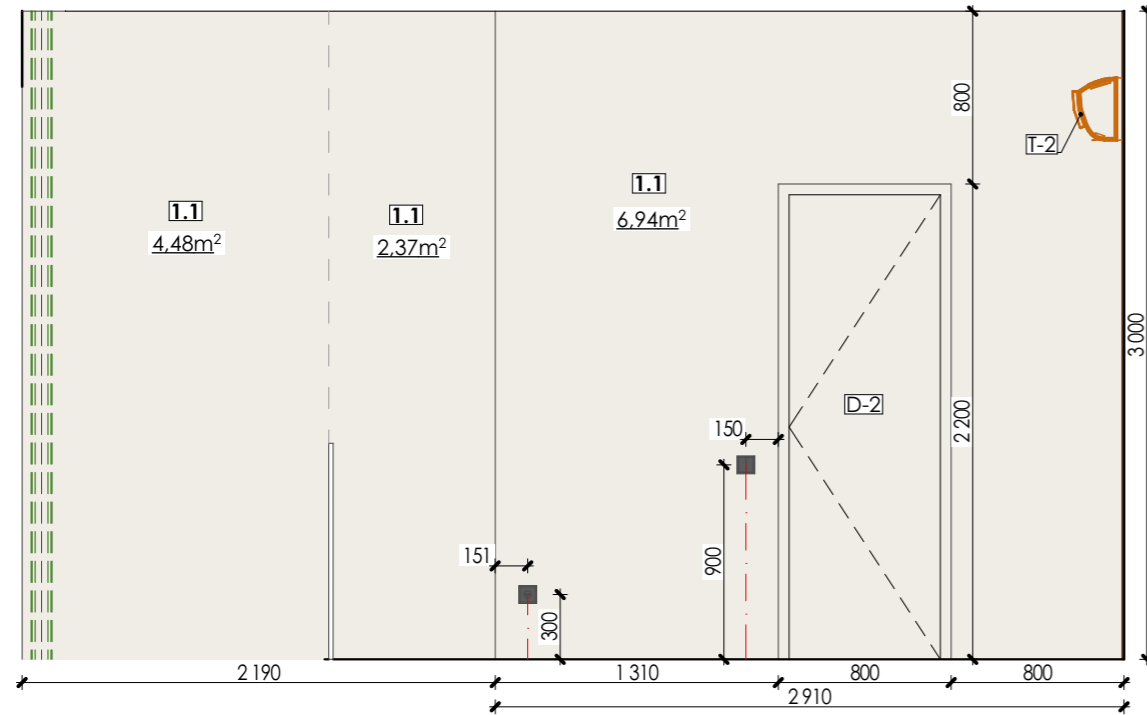

Legend:

- LED

- ID of the covering

Note:

Elevation layout 3


Scale
1:50

Sheet
7.4


Architect:

SNAAR


07 1-2

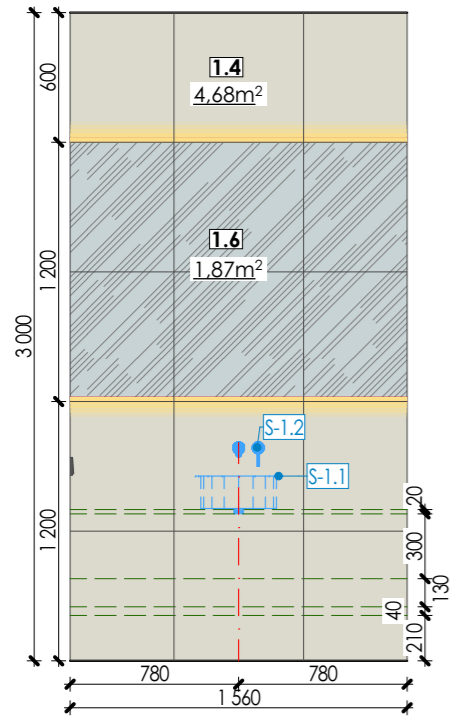


07 2-3

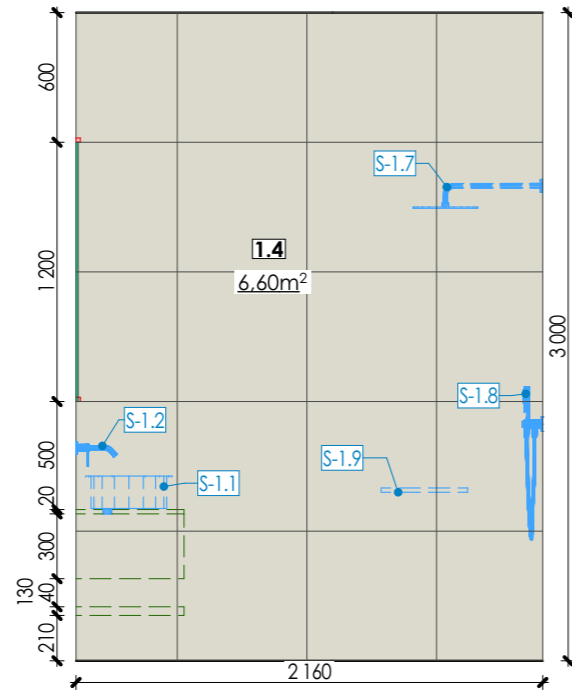

07 3-4

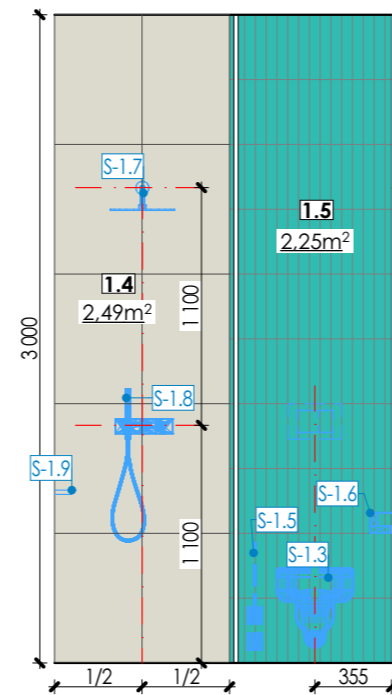

07 4-1

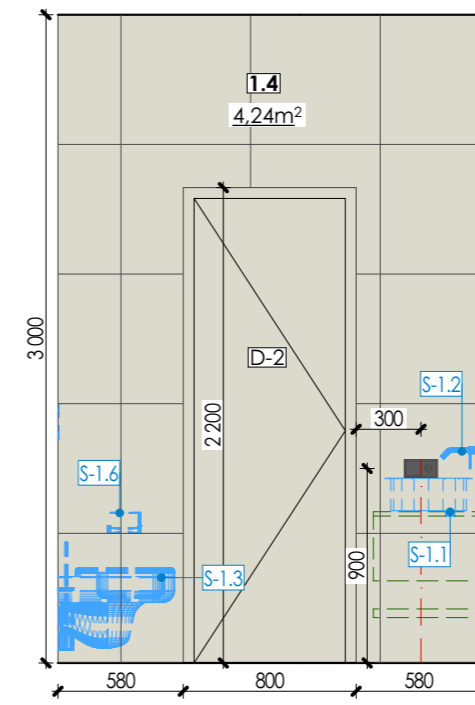

Note:




Elevation layout 4

Scale
1:50

Sheet
7.5

Architect:

SNAAR

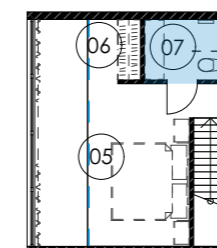

Legend:


- LED

- ID of the covering


Furniture marking layout

Note:

Ground floor

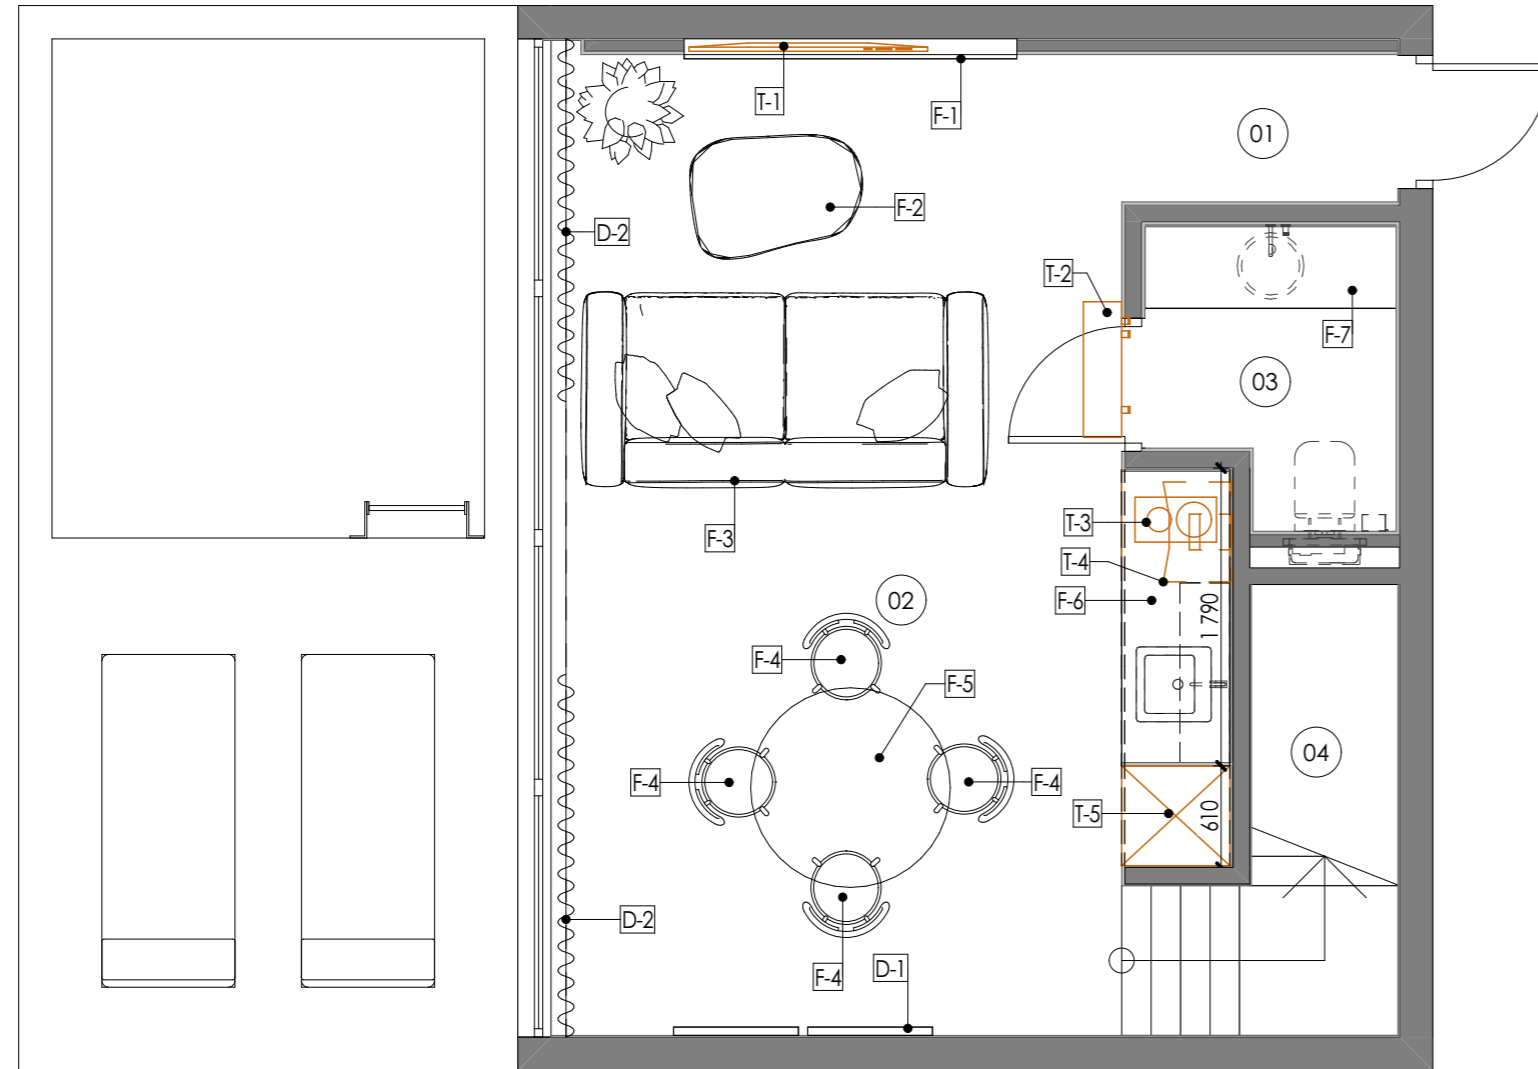

First floor

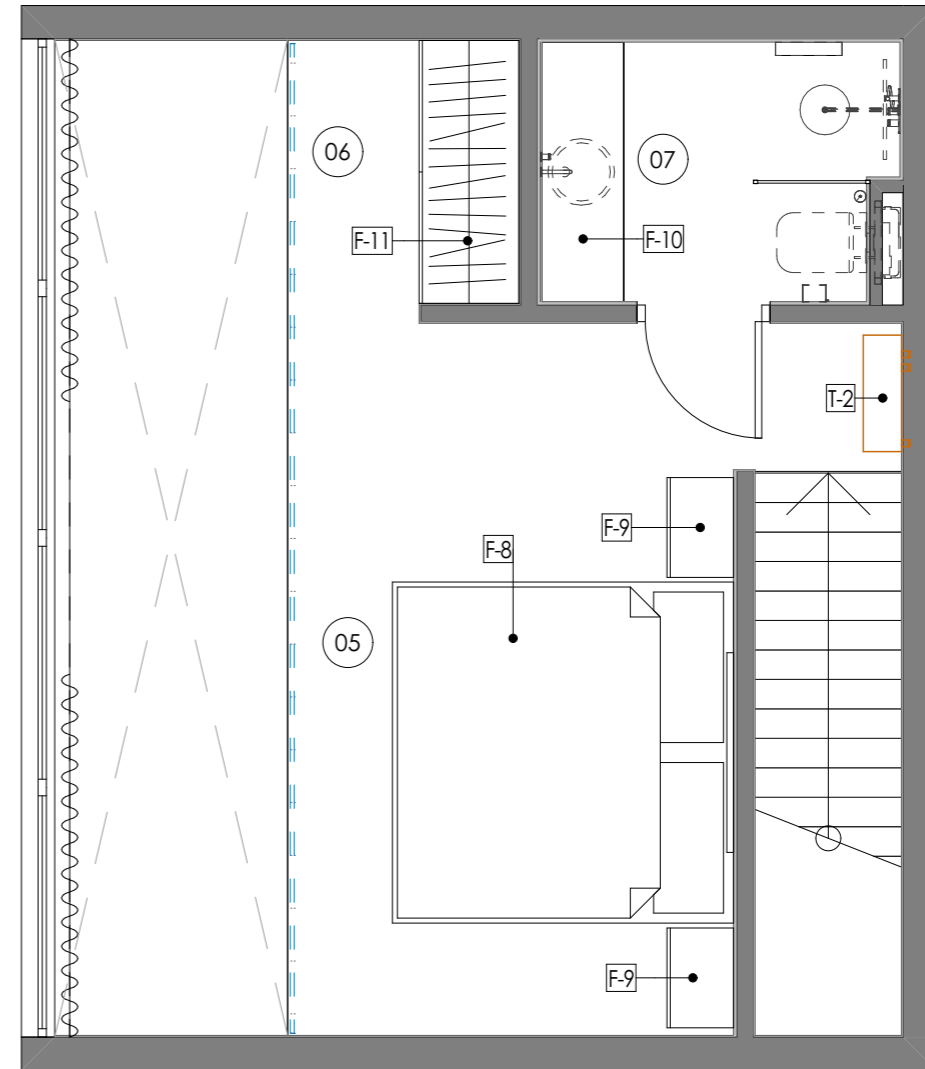

Furniture specification				
ID	2D Preview	Name	Amount	Visualisation
D-1		Picture composition	1	
D-2		Curtains	1	
F-1		Shelves	1	
F-2		Coffee table	1	

Furniture specification				
ID	2D Preview	Name	Amount	Visualisation
F-3		Sofa 1180x2450mm	1	
F-4		Chair	4	
F-5		Dining table D=1200mm	1	
F-6		Kitchen 2380x650x3000mm	1	

Furniture specification				
ID	2D Preview	Name	Amount	Visualisation
F-7		Washbasin cabinet 500x1510mm	1	
F-8		Bed 2050x2050mm	1	
F-9		Bedside table 600x400x200mm	2	
F-10		Washbasin cabinet 500x1560mm	1	

Furniture specification				
ID	2D Preview	Name	Amount	Visualisation
F-11		Wardrobe 1580x600x3000mm	1	
			17	

Technique specification			
ID	2D Preview	Name	Amount
T-1		TV	1
T-2		Air conditioner	2
T-3		Cooktop	1
T-4		Kitchen hood	1
T-5		Built-in fridge	1
			6

Furniture marking layout

Scale 1:50

Sheet 07.1

Architect:

SNAAR